

DOCUMENT 00 90 00
ADDENDUM

ADDENDUM No.: 2

DATE: February 24, 2026

RE: WESTERN TECHNICAL COLLEGE
KUMM CENTER STUDENT UNION REMODEL
400 N. 6TH STREET
LA CROSSE, WISCONSIN 54601

PROJECT No.: 25041

FROM: HSR Associates, Inc
100 Milwaukee Street
La Crosse, WI 54603
(608) 784-1830

TO: Prospective Bidders

This addendum forms a part of the Contract Documents and modifies the original Bidding Documents dated February 2026. Acknowledge receipt of this Addendum in the space provided on the bid form. Failure to do so may subject the Bidder to disqualification.

This Addendum consists of: 2 pages, 1 document, 0 sections, and 5 drawings.

PRE-BID MEETING SIGN IN SHEET:

1. Pre-Bid Meeting Sign-In Sheet February 18, 2026

CHANGES TO DRAWINGS

2. Sheet A090 DEMOLITION PLAN 30"x42"
 - a. See the revised sheet included in this addendum. Disregard the previous version.
 - b. Keynote 18 updated.
3. Sheet ED02 ELECTRICAL POWER AND LOW VOLTAGE REMOVAL PLAN 30"x42"
 - a. See the revised sheet included in this addendum. Disregard the previous version.
 - b. Refer to Vestibule #101 and Corridor #102;
 - i. Disconnect Two (2) existing motorized door openers for removal by others on existing doors. Please note, existing motorized door openers to be removed and a new replacement door openers to be installed on same existing doors. Reuse existing branch-circuit wiring and low voltage control wiring and paddle type switches for replacement door openers. Coordinate with General Contractor and visit site to determine scope of work prior to submitting bid.

4. Sheet E100 ELECTRICAL LIGHTING PLAN 30"x42"
 - a. See the revised sheet included in this addendum. Disregard the previous version.
 - b. Refer to Offices #104A, #104B, #104C, #104D, #104F, #104G, #104H and #106;
 - i. Change light fixture type from AD4 to AD5S. Please note this lighting fixture will change from 5,000 lumens to 6,000 lumens.
5. Sheet E200 POWER PLAN 30"x42"
 - a. See the revised sheet included in this addendum. Disregard the previous version.
 - b. Refer to Vestibule #101 and Corridor #102;
 - i. Reconnect Two (2) new replacement motorized door openers and associated low voltage control switches on existing doors. Please note, Two (2) motorized door openers were previously disconnected for removal and Two (2) new replacement motorized door openers were installed on existing doors. Reuse existing branch-circuit wiring, low voltage wiring and paddle type control switches. Coordinate with General Contractor, field verify existing conditions prior to submitting bid to determine scope of work.
6. Sheet E500 ELECTRICAL SCHEDULES 30"x42"
 - a. See the revised sheet included in this addendum. Disregard the previous version.
 - b. Refer to Lighting Fixture Schedule;
 - i. Type AD5S lighting fixture was added to Lighting Fixture Schedule.

END OF DOCUMENT 00 90 00

HSR Associates

Celebrating over **70 Years** of Innovative Design

SIGN-IN SHEET

PLEASE PRINT ALL
INFORMATION CLEARLY

PROJECT: WTC KUMM CTR STUDENT UNION REMODEL

HSR NO.: 25041 DATE: 2/18/2026

NAME	COMPANY	E-MAIL ADDRESS	TELEPHONE
Alyssa Frank	HSR Associates	afrank@hsrassociates.com	608.784.1830
Brandy Ernst	HSR	bernst@hsrassociates.com	" "
Gene McCurdy	WTC		
Matt Meyer	Wieser Brothers	estimating@wieserbrothers.com	507 895 8903
MIKE AUVEN	FOWLER & HAMMER	bids@fowlerhammer.com	608-782-6849
Tyler Richling	Fowler & Hammer	"	"
Reed Willadsen	Kish Electric	bids@kishelectric.com	608-863-6485
Colton Pahnke	Hoef Builders	CPahnke@hoefbuilders.com	715-495-6055
Josiah Hansons	Hoef Builders	JosiahH@hoefbuilders.com	715-442-8067
Eric Prieur	Builders Flooring	eprieur@buildersflooringinc.net	608-792-5847
Fernando Lobato	WHV	FLOBATO@WHVR.com	608-397-3016
Sam Furtak	Market + Johnson	bidding@market-johnson.com	608-784-5000
Jason Belter	Fireline Sprinkler	Jason.belter@firelinesprinkler.com	608-864-0257
Rick Iverson	Rye Barker Fire	Rick.Iverson@ryebarkerfire.com	507 358 0645
Mac Smith	B+B Electric	msmith@b-belectricinc.com	715-492-9427
Bob VonRuden	HJ Martin	b.vonruden@hjmartin.com	608 606 0150
Tom Christman	LVC Companies	tchristman@LVCINC.com	715 450-7497
Chris Helgerson	Bernie Buchner	chrishelgerson@BernieBuchnerInc.com	608-667-0028
Bart Greiner	JFAhern	bgreiner@jfahern.com	715-210-0964

Page Intentionally Left Blank




- DEMOLITION GENERAL NOTES:**
 - A. ALL ITEMS SHOWN DASHED ON DEMOLITION PLANS SHALL BE REMOVED FROM THE SITE UNLESS OTHERWISE NOTED. REFERENCE MEP DRAWINGS FOR APPLICABLE EQUIPMENT REMOVALS AND MODIFICATIONS. COORDINATE PATCHING AT EQUIPMENT REMOVALS.
 - B. AT WALL TYPES/MATERIALS, PREPARATION FOR NEW FINISHES SHALL INCLUDE, BUT NOT BE LIMITED TO REMOVAL OF EXISTING FINISHES, TAPES, GLUES/MASTIC, NAILS AND RELATED ITEMS. PATCHING OF HOLES, INDENTATIONS AND CRACKS FOR AN ACCEPTABLE SURFACE FOR NEW FINISH INSTALLATION.
 - C. OWNER WILL REMOVE LOOSE FURNISHINGS AND EQUIPMENT FROM THE WORK AREA PRIOR TO START OF CONSTRUCTION.
 - D. MAINTAIN ALL EXIT DOORS AND CORRIDORS IN UNOBSTRUCTED OPERABLE CONDITION WITH SAFE PASSAGE AWAY FROM THE BUILDING.
 - E. ROOM NUMBERS ARE SHOWN ON THIS PLAN FOR INFORMATIONAL AND COORDINATION PURPOSES ONLY.
 - F. COORDINATE STORAGE LOCATIONS FOR SALVAGED ITEMS WITH OWNER.
 - G. PROVIDE FLOOR PROTECTION AS SPECIFIED AT DEBRIS REMOVAL PATHS THROUGH BUILDING.
- DEMOLITION PLAN LEGEND:**
 - SYMBOL INDICATES CONSTRUCTION NOTE THIS SHEET
 - REMOVE ITEMS NOTED WITH DASHED LINES
 - SYMBOL INDICATES REMOVAL OF DOOR AND FRAME UNLESS NOTED OTHERWISE

KEY NOTES DEMOLITION	
1	REMOVE MASONRY WALL TO EXISTING B.O. STONE - 12'-0" +/- AFF.
2	REMOVE STUD PARTITION
3	REMOVE STUD PARTITION AND BOOTHS
4	REMOVE DOOR AND FRAME, INCLUDING SIDELIGHT AND TRANSOM WINDOW WHERE APPLICABLE. ALL LOCKSETS TO BE SALVAGED BACK TO OWNER.
5	REMOVE CASEWORK AND COUNTERTOP
6	REMOVE ACT CEILING
7	REMOVE WOOD TILE CEILING
8	REMOVE GYP BD BULKHEAD, CEILING, AND FRAMING
9	REMOVE LINEAR METAL CEILING
10	MODIFY EXISTING CEILING GRID AND TILES AS REQUIRED FOR NEW LAYOUT.
11	REMOVE OPT FLOORING
12	REMOVE LVT FLOORING
13	MODIFY EXISTING FLOORING AS REQUIRED FOR NEW LAYOUT.
14	REMOVE TRIM, SHELVING, AND BUILT-IN CASEWORK - PATCH AND PAINT. SEE 614/400.
15	REMOVE ELECTRICAL COVER PLATE - PATCH AND PAINT. SEE 614/400.
16	REMOVE RESTROOM STALL PARTITIONS. PATCH AND REPAIR ALL PREVIOUS PARTS OF CONSTRUCTION.
17	PORTABLE STAGE TO BE REMOVED AND SALVAGED BY OWNER
18	REMOVE PORTABLE FURNITURE PARTITIONS
19	EXISTING SPRINKLER TO BE REMOVED AND REINSTALLED BY OWNER
20	EXISTING WALL MOUNTED MONITOR TO BE REMOVED AND REINSTALLED BY OWNER
21	EXISTING PROJECTOR TO BE REMOVED AND REINSTALLED BY OWNER
22	EXISTING FURNITURE PHONE BOOTH TO BE REMOVED AND REINSTALLED BY OWNER
23	EXISTING ATM TO BE REMOVED AND REINSTALLED BY OWNER
24	EXISTING VENDING TO BE REMOVED AND REINSTALLED BY OWNER
25	SAW OUT FLOOR FOR NEW FOLDING PARTITION FLOOR TRACK
26	SAW OUT FLOOR AT EXISTING CONDUIT FOR NEW FLOOR OUTLET - SEE ELECTRICAL
27	ALTERNATE: CORE DRILL FLOOR NEW FLOOR OUTLET - SEE ELECTRICAL
28	GRIND TERRAZZO EDGE FOR SMOOTH ELEVATION CHANGE UNDER NEW FLOOR FINISH.

1

DEMOLITION PLAN

3/16" = 1'-0"

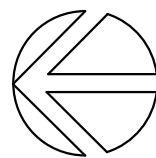

ARCHITECTURE
ENGINEERING
INTERIOR DESIGN



HSR ASSOCIATES INC.
100 MILWAUKEE STREET
LA CROSSE, WISCONSIN
PHONE: 608.784.1830
FAX: 608.782.5844
www.hsrassociates.com

Consultant:

Project Title: WESTERN TECHNICAL COLLEGE
KUMM CENTER STUDENT UNION REMODEL
Project Location: 400 6th St N
La Crosse WI 54601
Sheet Title: DEMOLITION PLAN

HSR Project Number: 25041
Project Date: FEBRUARY 2026
Drawn By: HSR

Key Plan:

No.	Description	Date
A02	Addendum 2	02/24/2026

Graphic Scale:

Last Update:
2/24/2026 11:28:52 AM

A090



PHOTO #1

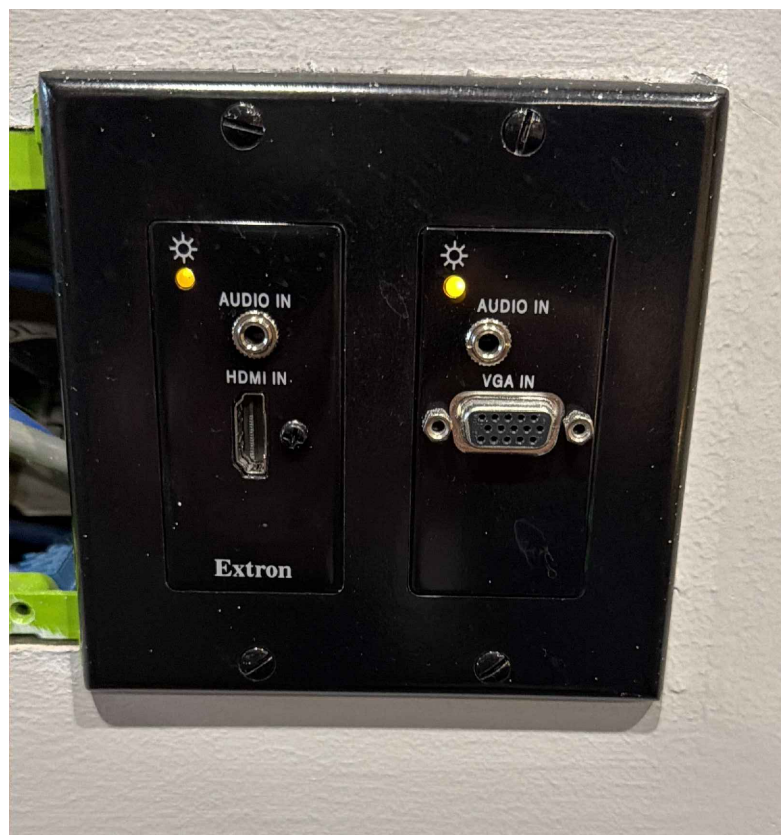


PHOTO #2

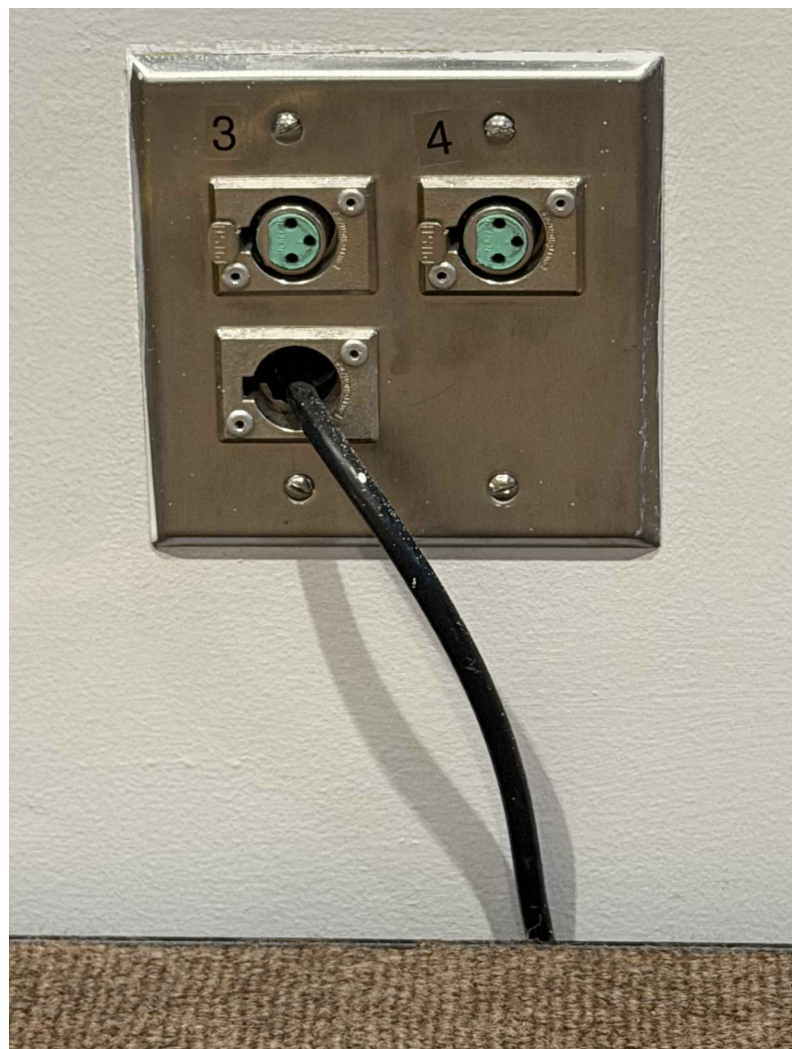


PHOTO #3

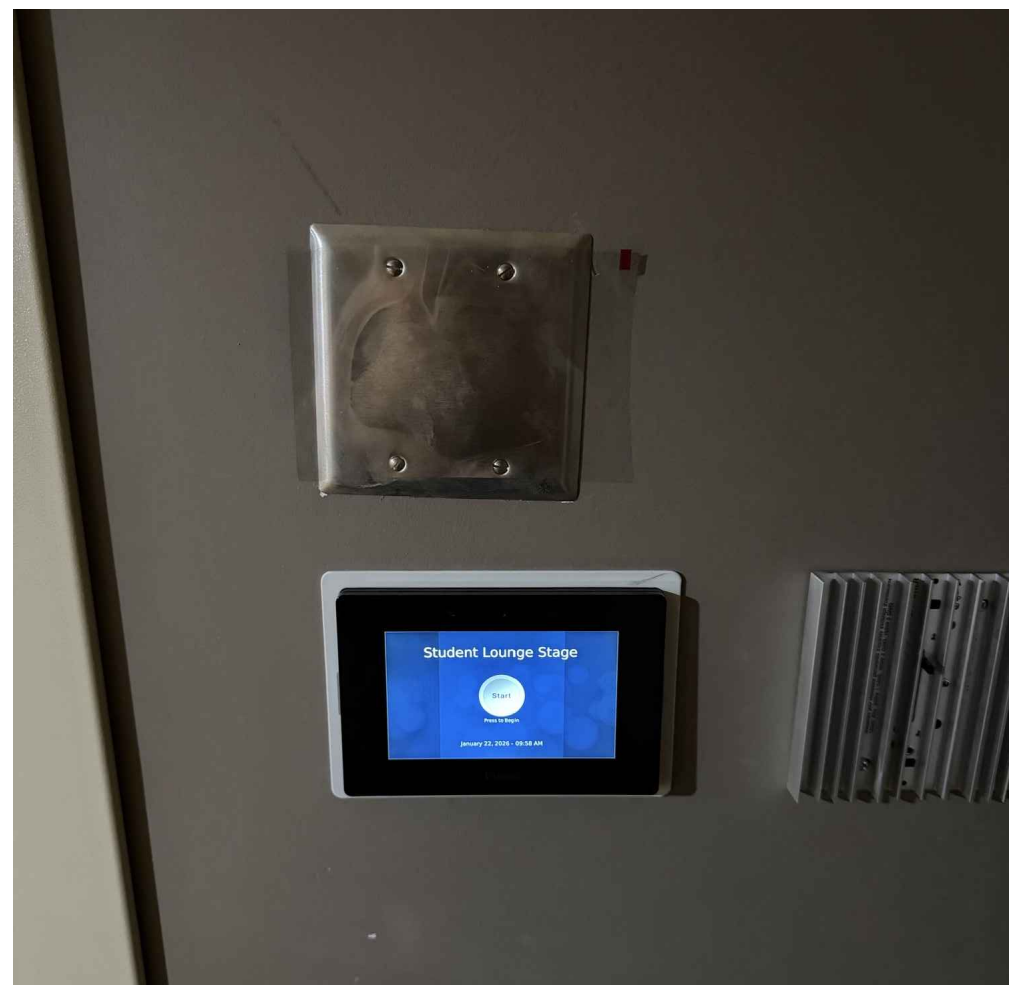


PHOTO #4


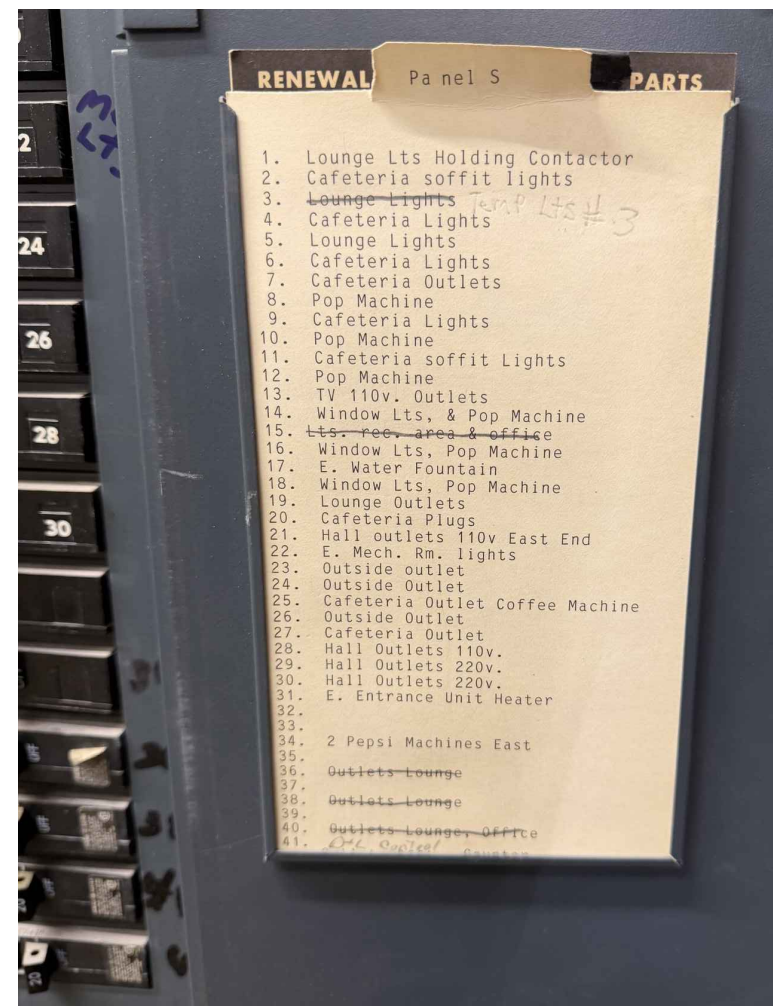


PHOTO #5



PHOTO #6

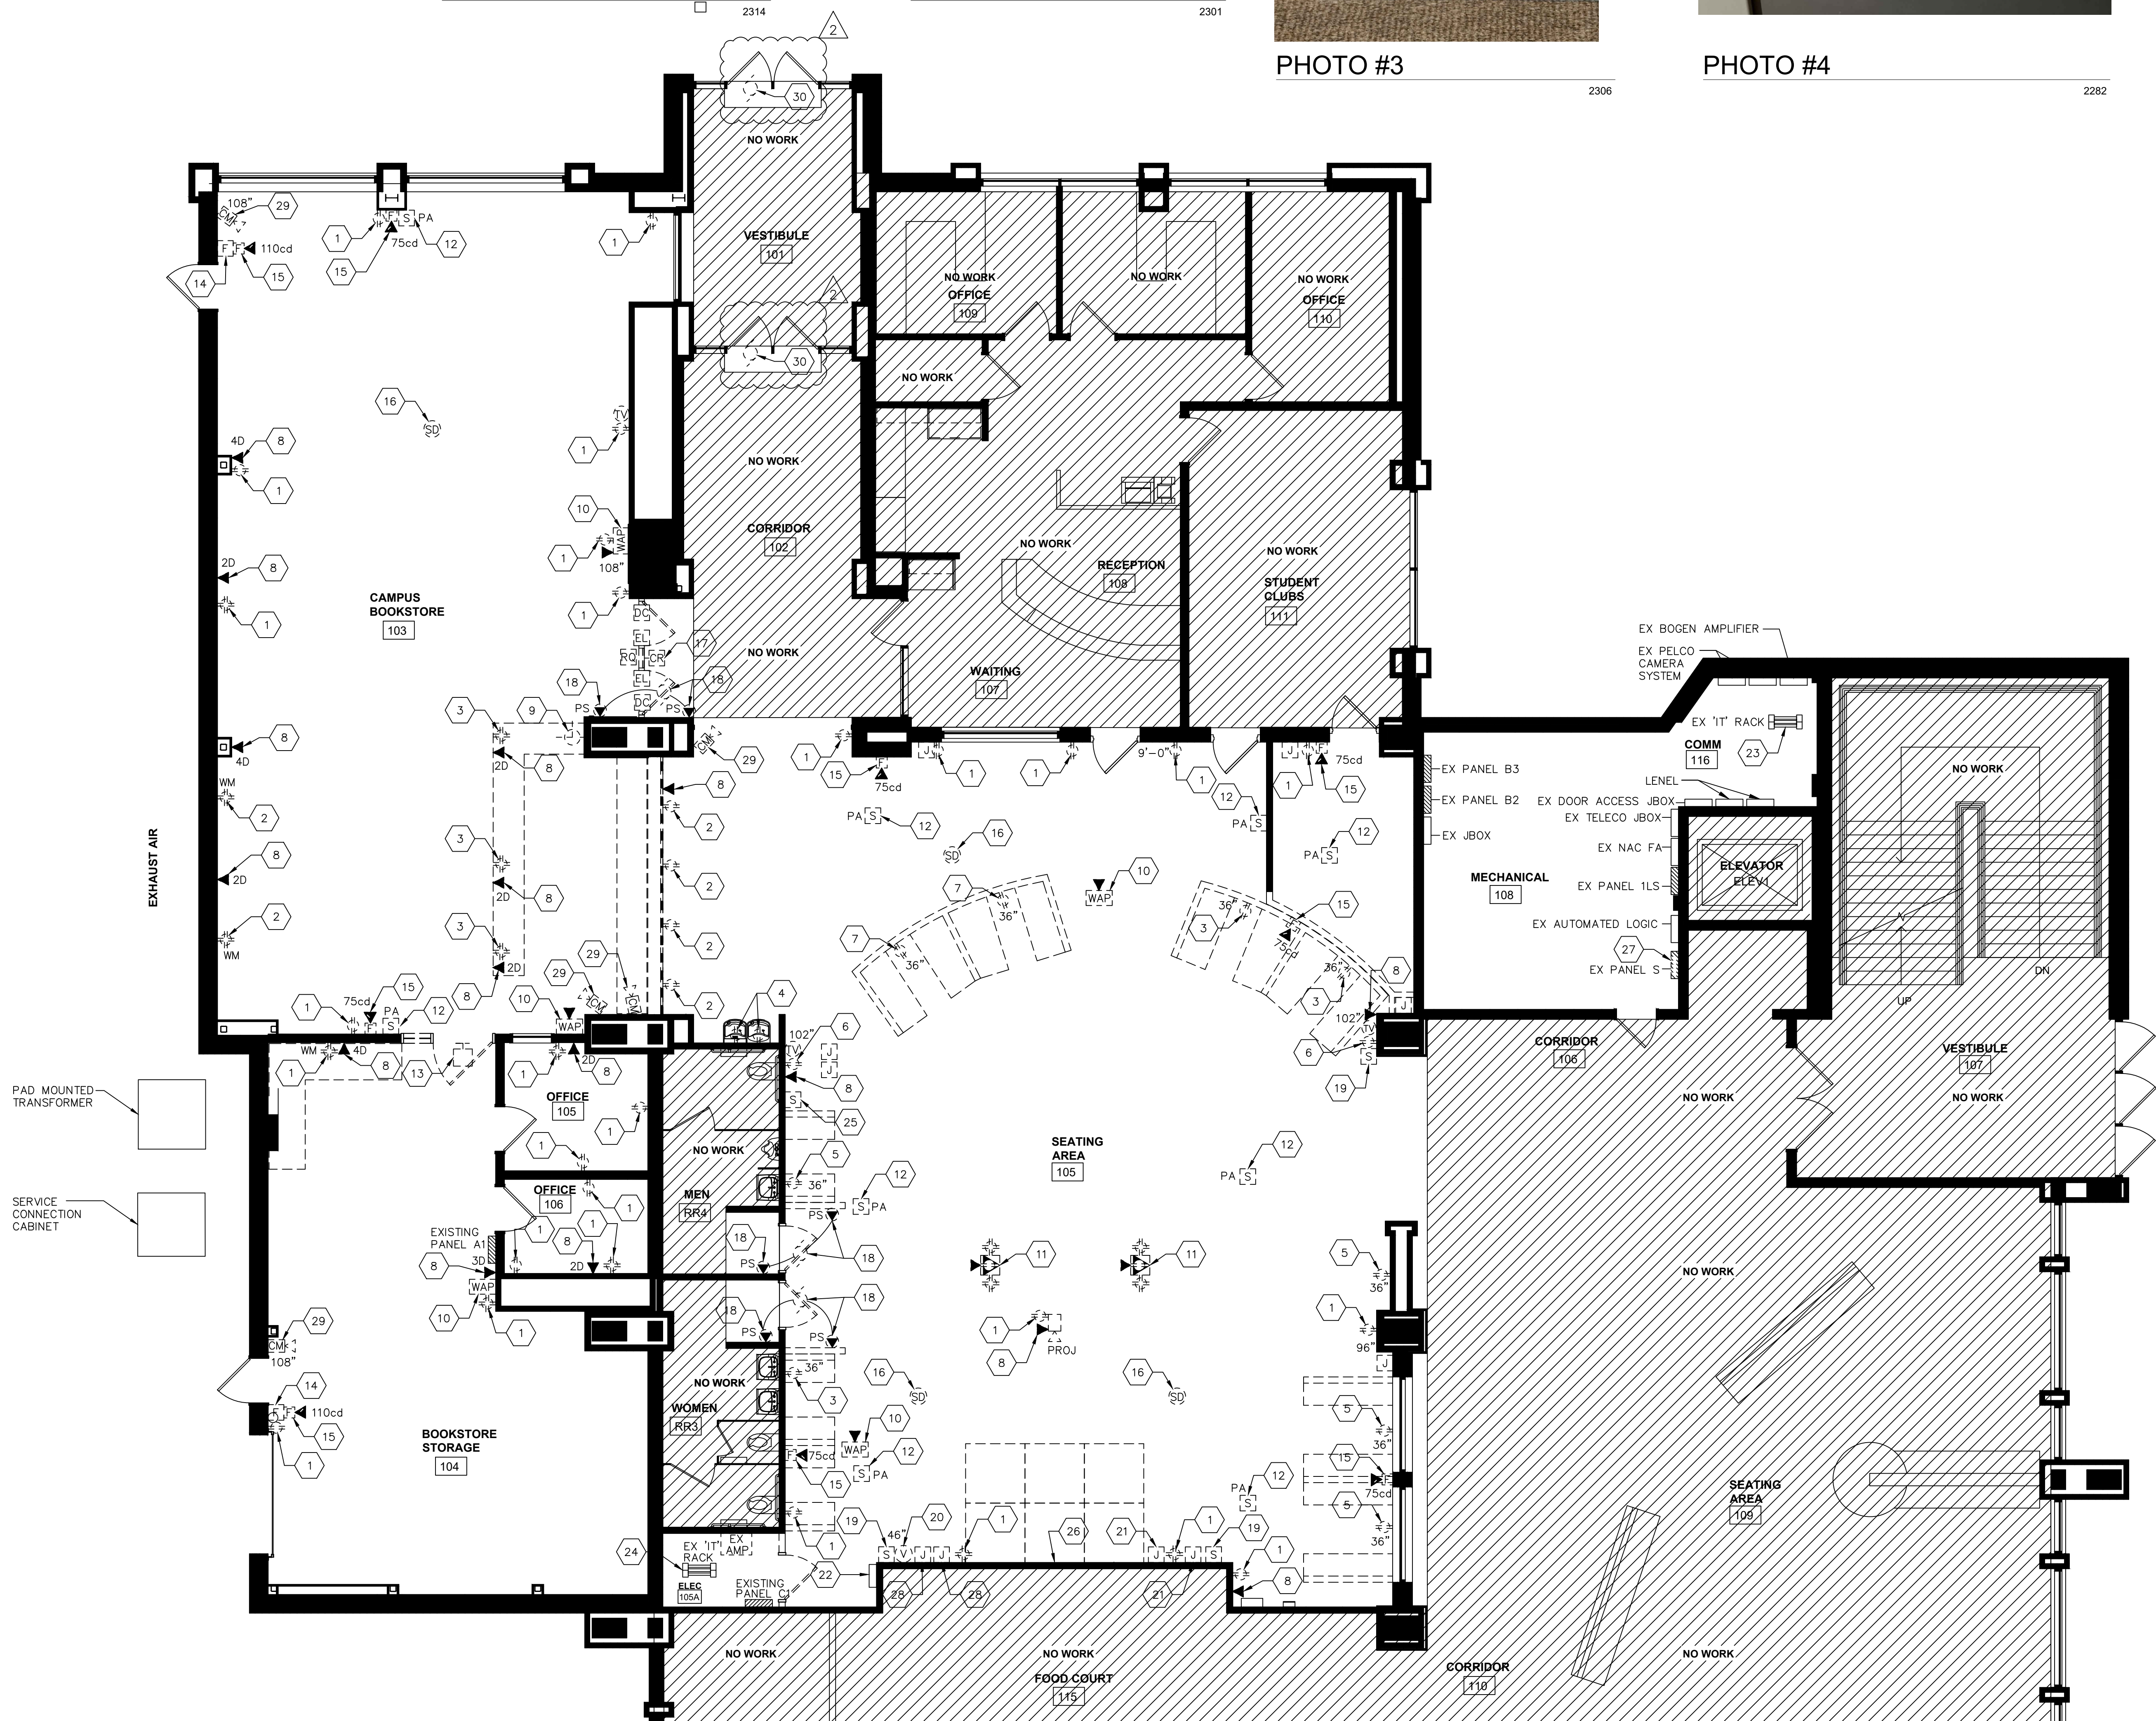

GENERAL REMOVAL NOTES:

- DEMOLITION NOTES AND SYMBOLS ARE BASED UPON EXISTING DRAWINGS AND CASUAL OBSERVATION OF BUILDING AND DOES NOT INCLUDE A COMPLETE LIST OF DEMOLITION ITEMS.
- RECOMMEND ELECTRICAL CONTRACTOR VISIT EXISTING SITE TO DETERMINE SCOPE OF WORK PRIOR TO SUBMITTING BID.
- NO EXISTING ELECTRICAL ITEMS REMOVED SHALL BE REUSED FOR THIS PROJECT UNLESS NOTED OTHERWISE.
- IT SHALL BE ALLOWED TO REUSE ALL EXISTING JUNCTION BOXES, CONDUIT, STRAPS, BRANCH-CIRCUIT WIRING AND SWITCH-LEG WIRING TO THE EXTENT POSSIBLE. IT IS **NOT** ALLOWED TO REUSE EXISTING LOW VOLTAGE WIRING UNLESS APPROVED BY WTC IT DEPARTMENT.

KEYED ELECTRICAL REMOVAL PLAN NOTES POWER AND LOW VOLTAGE - ED02:

- DISCONNECT, REMOVE AND DISPOSE OF EXISTING DUPLEX RECEPTACLE(S). REUSE EXISTING BRANCH-CIRCUIT WIRING, JUNCTION BOXES, CONDUIT, ETC. TO THE EXTENT POSSIBLE FOR REMODEL WORK.
- DISCONNECT, REMOVE AND DISPOSE OF EXISTING SURFACE 'WIREMOLD' RACEWAY AND RECEPTACLES. REMOVE WIRING BACK TO SOURCE, DO NOT REUSE OR ABANDON IN PLACE.
- DISCONNECT, REMOVE AND DISPOSE OF EXISTING DUPLEX RECEPTACLE(S). REMOVE EXISTING BRANCH-CIRCUIT WIRING, CONDUIT, JUNCTION BOXES, ETC. BACK TO SOURCE.
- EXISTING DUPLEX RECEPTACLE TO REMAIN AS IS FOR WATER COOLER. FIELD VERIFY RECEPTACLE IS GFCI PROTECTED. IF THE RECEPTACLE IS NOT GFCI PROTECTED PROVIDE A GFCI CIRCUIT BREAKER FEEDING THIS BRANCH-CIRCUIT OR PROVIDE A GFCI DUPLEX RECEPTACLE.
- DISCONNECT, REMOVE AND DISPOSE OF EXISTING DUPLEX RECEPTACLE(S). REUSE EXISTING BRANCH-CIRCUIT WIRING, JUNCTION BOXES, CONDUIT, ETC. TO THE EXTENT POSSIBLE FOR REMODEL WORK. HOWEVER, IT WILL BE REQUIRED TO LOWER THIS RECEPTACLE TO 18" ABOVE FINISHED FLOOR.
- DISCONNECT, REMOVE AND DISPOSE OF EXISTING DUPLEX RECEPTACLE(S). REUSE EXISTING BRANCH-CIRCUIT WIRING, JUNCTION BOXES, CONDUIT, ETC. TO THE EXTENT POSSIBLE FOR REMODEL WORK. PLEASE NOTE THIS RECEPTACLE IS LOCATED HIGH ON THE WALL AND USED FOR WALL-MOUNTED INFORMATION MONITOR.
- DISCONNECT, REMOVE AND DISPOSE OF EXISTING WALL TO BE DEMOLISHED. HOWEVER IT IS DESIRED TO INSTALL A FLOOR BOX IN THE LOCATION WHERE THE CONDUIT RISES ABOVE CONCRETE FLOOR TO FEED RECEPTACLE. IT WILL BE REQUIRED TO SAWCUT EXISTING CONCRETE FLOOR TO INSTALL NEW FLOOR BOX. REFER TO SHEET E200 FOR ADDITIONAL INFORMATION.
- DISCONNECT, REMOVE AND DISPOSE OF EXISTING DATA JACK(S). REMOVE LOW VOLTAGE WIRING BACK TO SOURCE LOCATED IN COMM ROOM #116. DO NOT ABANDON IN PLACE OR REUSE. IT SHALL BE ALLOWED TO REUSE EMPTY CONDUIT, JUNCTION BOXES, ETC. FOR NEW DATA JACKS TO BE INSTALLED IN SAME LOCATION. COORDINATE THOROUGHLY WITH WTC IT DEPARTMENT.
- DISCONNECT, REMOVE AND SALVAGE EXISTING CLOCK TO OWNER. DISCONNECT, REMOVE ASSOCIATED BRANCH-CIRCUIT WIRING BACK TO SOURCE.
- DISCONNECT, REMOVE AND SALVAGE EXISTING WIRELESS ACCESS POINT TO WTC IT DEPARTMENT. REMOVE LOW VOLTAGE WIRING BACK TO SOURCE LOCATED IN COMM ROOM #116. DO NOT ABANDON IN PLACE OR REUSE. TYPICAL.
- EXISTING FLOOR BOX TO REMAIN AS IS. HOWEVER THE DATA JACKS WILL NO LONGER BE USED. REMOVE LOW VOLTAGE WIRING BACK TO SOURCE IF REASONABLE TO DO SO. IT WILL BE REQUIRED TO PROVIDE NEW FLOOR BOX COVERS, THE EXISTING COVER PLATE HAS BEEN DAMAGED TO OVERUSE. COORDINATE WITH 'WIREMOLD' REPRESENTATIVE FOR EXACT MODEL NUMBER FOR REPLACEMENT. COORDINATE WITH WTC FACILITY DEPARTMENT. REFER TO **PHOTO #1/ED02**.
- DISCONNECT, REMOVE AND DISPOSE OF EXISTING PUBLIC ADDRESS SYSTEM SPEAKER. REMOVE ASSOCIATED LOW VOLTAGE WIRING BACK TO SOURCE, DO NOT REUSE OR ABANDON IN PLACE. PLEASE NOTE P.A. AMPLIFIER IS LOCATED IN **COMM ROOM #116**. TYPICAL.
- DISCONNECT, REMOVE AND DISPOSE OF EXISTING DOORBELL SYSTEM. REMOVE ASSOCIATED LOW VOLTAGE WIRING BACK TO SOURCE. DO NOT ABANDON IN PLACE OR REUSE.
- EXISTING MANUAL FIRE ALARM SYSTEM PULL STATION TO REMAIN AS IS.
- DISCONNECT, REMOVE AND DISPOSE OF EXISTING WALL-MOUNTED 'TEST' FIRE ALARM SYSTEM NOTIFICATION DEVICE. PROVIDE A BLANK COVER PLATE FOR JUNCTION BOX. IT SHALL BE ALLOWED TO REUSE EXISTING FIRE ALARM SYSTEM WIRING TO THE EXTENT POSSIBLE FOR NEW REMODEL WORK.
- DISCONNECT, REMOVE AND DISPOSE OF EXISTING CEILING-MOUNTED 'TEST' FIRE ALARM SYSTEM SMOKE DETECTOR. IT SHALL BE ALLOWED TO REUSE EXISTING FIRE ALARM SYSTEM WIRING TO THE EXTENT POSSIBLE FOR NEW REMODEL WORK.
- DISCONNECT, REMOVE AND REINSTALL DOOR ACCESS CARD READER, DOOR CONTACTS, REQUEST TO EXIT AND ELECTRIC LOCK FOR NEW DOOR PROVIDED AS A REPLACEMENT. REUSE EXISTING DOOR ACCESS CONTROL WIRING TO THE EXTENT POSSIBLE. PLEASE NOTE 'LENEL' DOOR ACCESS CONTROL PANELS ARE LOCATED IN **COMM ROOM #116**.
- PLEASE NOTE EXISTING DOOR SHALL BE REMOVED AND REPLACED WITH NEW. DISCONNECT EXISTING MOTORIZED DOOR OPENER AND PUSH BUTTON(S) FOR DOOR OPENER AND RECONNECT TO NEW MOTORIZED DOOR OPENER FOR NEW REPLACEMENT DOOR. REUSE EXISTING LOW VOLTAGE CONTROL WIRING AND BRANCH-CIRCUIT WIRING TO THE EXTENT POSSIBLE. COORDINATE WITH GENERAL CONTRACTOR.
- EXISTING A/V SYSTEM AUDIO SPEAKER TO REMAIN AS IS. PLEASE NOTE A/V SYSTEM EQUIPMENT RACK LOCATED IN **ELECTRICAL ROOM #105A**.
- DISCONNECT, REMOVE AND DISPOSE OF EXISTING VOLUME CONTROL SWITCH. REMOVE EXISTING JUNCTION BOX. GENERAL CONTRACTOR SHALL REPAIR, PATCH AND PAINT WALL. REMOVE LOW VOLTAGE WIRING BACK TO SOURCE, DO NOT ABANDON IN PLACE.
- DISCONNECT, REMOVE AND REINSTALL EXISTING A/V SYSTEM LOW VOLTAGE JACKS AS NOTED ON SHEET E300. THE INTENT IS TO REMOVE EXISTING A/V JACKS AND REINSTALL IN NEW LOCATION AS NOTED ON SHEET E300. REFER TO **PHOTOS #2/ED02 & #3/ED02**.
- DISCONNECT, REMOVE AND REINSTALL EXISTING A/V SYSTEM TOUCH PAD CONTROL PANEL TO NEW STAGE AREA. REFER TO SHEET E300 FOR LOCATION. COORDINATE WITH WTC IT DEPARTMENT. REFER TO **PHOTO #4/ED02**.
- LOCATION OF EXISTING COMMUNICATION EQUIPMENT RACK. IT WILL BE REQUIRED TO UPDATE EXISTING RACK WITH CAT6A DATA PATCH PANELS FOR NEW DATA JACKS TO BE INSTALLED. COORDINATE WITH WTC IT DEPARTMENT. REFER TO **PHOTO #5/ED02**.
- LOCATION OF EXISTING A/V EQUIPMENT RACK. REFER TO **PHOTO #1/E300**.
- DISCONNECT, REMOVE AND SALVAGE EXISTING AUDIO WALL-SPEAKER FOR REINSTALLATION AS NOTED ON SHEET E300. PLEASE NOTE A/V EQUIPMENT RACK LOCATED IN **ELECTRICAL ROOM #105A**.
- ALL A/V JUNCTION BOXES ABANDONED ON THIS WALL SHALL BE REMOVED BY EC. THE WALL WILL NEED TO BE PATCHED AND PAINTED BY GENERAL CONTRACTOR, THIS WALL IS USED AS A VIDEO PROJECTION SCREEN WALL.
- ELECTRICAL CONTRACTOR SHALL DISCONNECT, REMOVE AND DISPOSE OF EXISTING 'GENERAL ELECTRIC', 100AMP, 120/208VAC, 3-PHASE, 4-WIRE 42 SPACE, MAIN LUG ONLY PANELBOARD AND REPLACE WITH A NEW 125 AMP, 120/208VAC, 3-PHASE, 4-WIRE, MAIN LUG ONLY 'SQUARE D' NO PANELBOARD. NO EQUALS ACCEPTED. INCLUDE AS ALTERNATE BID #3. REFER TO **PHOTOS #6/ED02 AND #7/ED02**. RECOMMEND FIELD OBSERVATION PRIOR TO SUBMITTING BID TO DETERMINE SCOPE OF WORK. REFER TO PANELBOARD SCHEDULE.
- EXISTING A/V SYSTEM LOW VOLTAGE JACKS TO REMAIN AS IS. HOWEVER IT IS REQUIRED TO INSTALL A NEW 3-GANG COVER PLATE. REFER TO **PHOTO #2/ED02**. COORDINATE WITH WTC IT DEPARTMENT.
- DISCONNECT, REMOVE AND SALVAGE EXISTING CAMERA TO WTC IT DEPARTMENT. REMOVE LOW VOLTAGE WIRING BACK TO COMM ROOM #116.
- DISCONNECT EXISTING MOTORIZED DOOR OPENER AND PUSH BUTTON(S) FOR REMOVAL OF EXISTING DOOR OPENER AND RECONNECT TO NEW REPLACEMENT MOTORIZED DOOR OPENER FOR EXISTING DOOR. REUSE EXISTING LOW VOLTAGE CONTROL WIRING AND BRANCH-CIRCUIT WIRING TO THE EXTENT POSSIBLE. COORDINATE WITH GENERAL CONTRACTOR.

1 ELECTRICAL POWER & LOW VOLTAGE REMOVAL PLAN

3/16" = 1'-0"

ARCHITECTURE
ENGINEERING
INTERIOR DESIGN



HSR ASSOCIATES INC.
100 MILWAUKEE STREET
LA CROSSE, WISCONSIN
PHONE: 608.784.1830
FAX: 608.782.5844
www.hsrassociates.com

Consultant:




WESTERN TECHNICAL COLLEGE
KUMM STUDENT UNION REMODEL
Project Title:
Project Location: 400 6th St. N.
La Crosse WI 54601
Project Number: 25041
Project Date: FEBRUARY 2026
Drawn By: PLP
Key Plan:
Sheet Title: ELECTRICAL POWER & LOW VOLTAGE REMOVAL PLAN

No.	Description	Date
1	ADDENDUM # 2	02/24/26

Graphic Scale:
VARIES
Last Update:
2/03/2026

ED02

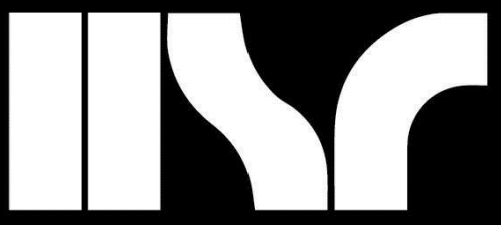

HSR ASSOCIATES INC.
100 MILWAUKEE STREET
LA CROSSE, WISCONSIN
PHONE: 608.784.1830
FAX: 608.782.5844
www.hsrassociates.com

Consultant:



2045 SUNDY STREET, SUITE 111
LA CROSSE, WISCONSIN 54601
PHONE: 608.784.1830
FAX: 608.782.5844
E-MAIL: info@galileoconsulting.com

WESTERN TECHNICAL COLLEGE
KUMM STUDENT UNION REMODEL
Project Location: 400 6th St. N.
La Crosse WI 54601
ELECTRICAL LIGHTING PLAN

Project Title:
HSR Project Number: 25041
Project Date: FEBRUARY 2026
Drawn By: PLP
Key Plan:

Revisions:

No. Description Date
ADDENDUM # 2 02/24/26

Graphic Scale:
VARIES

Last Update:
2/03/2026

E100

GENERAL NOTES FOR LIGHTING:

A. FINAL NIGHT OCCUPANCY SENSOR LOCATION SHALL BE BY OCCUPANCY SENSOR MANUFACTURER.


B. LIGHTING CONTROL SYSTEM SHALL BE AN N-LIGHT AIR WIRELESS SYSTEM WITH EMBEDDED DEVICES INSTALLED INTEGRAL WITH LIGHTING FIXTURES OR WITH REMOTE COMPATIBLE POWER PACK TYPE CONTROL DEVICES. PLEASE NOTE AN EMERGENCY GENERATOR IS AVAILABLE FOR THIS BUILDING.

C. LIGHTING CONTROL SYSTEM BASED UPON N-LIGHT MANUFACTURER. THE FOLLOWING EQUAL WILL BE ACCEPTED: WATTSTOPPER. REFER TO SHEETS E600-E606 FOR LIGHTING CONTROL DETAILS.

D. CONTACT ENTERPRISE LIGHTING & CONTROL, TIM MARTIN (CONTROLS SALES ENGINEER), 608-576-2557, tmartin@enterpriselighting.com.


E. THE ELECTRICAL CONTRACTOR SHALL PROVIDE A SEPARATE BREAK-OUT COST FOR 'N-LIGHT AIR' LIGHTING CONTROLS AND ENTERPRISE LIGHTING FIXTURE PACKAGE WHICH WAS USED AS THE BASIS OF DESIGN. IT IS MANDATORY TO PROVIDE COMPLETE LIGHTING CONTROLS DESIGN DRAWINGS WITH BID.

- KEYED LIGHTING PLAN NOTES E100:
1. PROVIDE AN N-LIGHT AIR WIRELESS 1-ZONE/2-ZONE DIMMING SWITCH. REFER TO INSTALLATION DETAILS ON SHEETS E600-E606. PROGRAM AS DIRECTED BY OWNER.
 2. PROVIDE AN N-LIGHT AIR WIRELESS 1-ZONE/2-ZONE DIMMING SWITCH. REUSE EXISTING JUNCTION BOX AND 120VAC BRANCH-CIRCUIT WIRING TO ENERGIZE DIMMING SWITCH. REFER TO INSTALLATION DETAILS ON SHEETS E600-E606.
 3. PROVIDE AN N-LIGHT AIR WIRELESS 4-BUTTON PRE-SET SCENE DIMMING SWITCH. PROGRAM AS DIRECTED BY OWNER. REFER TO INSTALLATION DETAILS ON SHEETS E600-E606.
 4. PROVIDE AN N-LIGHT AIR WIRELESS 4-BUTTON PRE-SET SCENE DIMMING SWITCH. REUSE EXISTING MULTI-GANG JUNCTION BOX AND 120VAC BRANCH-CIRCUIT WIRING TO ENERGIZE SCENE CONTROL SWITCH. PROVIDE A STAINLESS STEEL COVER PLATE WITH INSERTS FOR UNUSED GANG SPACES. PROGRAM AS DIRECTED BY OWNER. REFER TO INSTALLATION DETAILS ON SHEETS E600-E606.
 5. PROVIDE A SINGLE-POLE LIGHT SWITCH, IT IS NOT ALLOWED BY NEC TO INSTALL A OCCUPANCY SENSOR IN SAME AREA AS PANELBOARD PANEL.
 6. PROVIDE AN N-LIGHT TOUCH PAD LIGHTING CONTROL PANEL PER N-LIGHT CONTROL DRAWINGS.
 7. SUSPEND TRACK LIGHTING FROM CEILING AS DIRECTED BY OWNER TO BEST ILLUMINATE STAGE.
 8. PROVIDE A 20 AMP, 120VAC BRANCH-CIRCUIT CONNECTED TO LIFE SAFETY BRANCH EMERGENCY PANELBOARD '1LS' LOCATED IN HUB ROOM #108.
 9. PROVIDE A 20 AMP, 120VAC BRANCH-CIRCUIT TO EXISTING PANELBOARD 'X1' LOCATED ADJACENT TO WORK ROOM 104F.
 10. PROVIDE A 20 AMP, 120VAC BRANCH-CIRCUIT TO EXISTING PANELBOARD 'C1' LOCATED IN IT/AV ROOM 105A.
 11. PROVIDE AN N-LIGHT POWER PACK/RELAY PACK FOR WIRELESS OPERATION.
 12. PROVIDE A 20 AMP, 3-POLE, LIGHTING RELAY AND CONNECT TO EXISTING EXTERIOR WALL PACK TYPE LIGHTING FIXTURE. PROVIDE COIL VOLTAGE COMPATIBLE WITH BUILDING AUTOMATED LOGIC SYSTEM.
 13. CONNECT LIGHTING RELAY TO EXISTING BUILDING AUTOMATED LOGIC BAS SYSTEM CONTROL PANEL LOCATED IN HUB ROOM #108. COORDINATE PROGRAMMING OF EXTERIOR LIGHTING WITH WTC FACILITY DEPARTMENT.
 14. CONNECT EXISTING EXTERIOR WALL PACK LIGHTING FIXTURES TO LIGHTING RELAY AS REQUIRED. PLEASE NOTE THERE IS A 'HOT' BRANCH-CIRCUIT AT EXTERIOR LIGHTING FIXTURE, INTERRUPT EXISTING WIRING AS REQUIRED AND RE-ROUTE TO NEW LIGHTING RELAY.

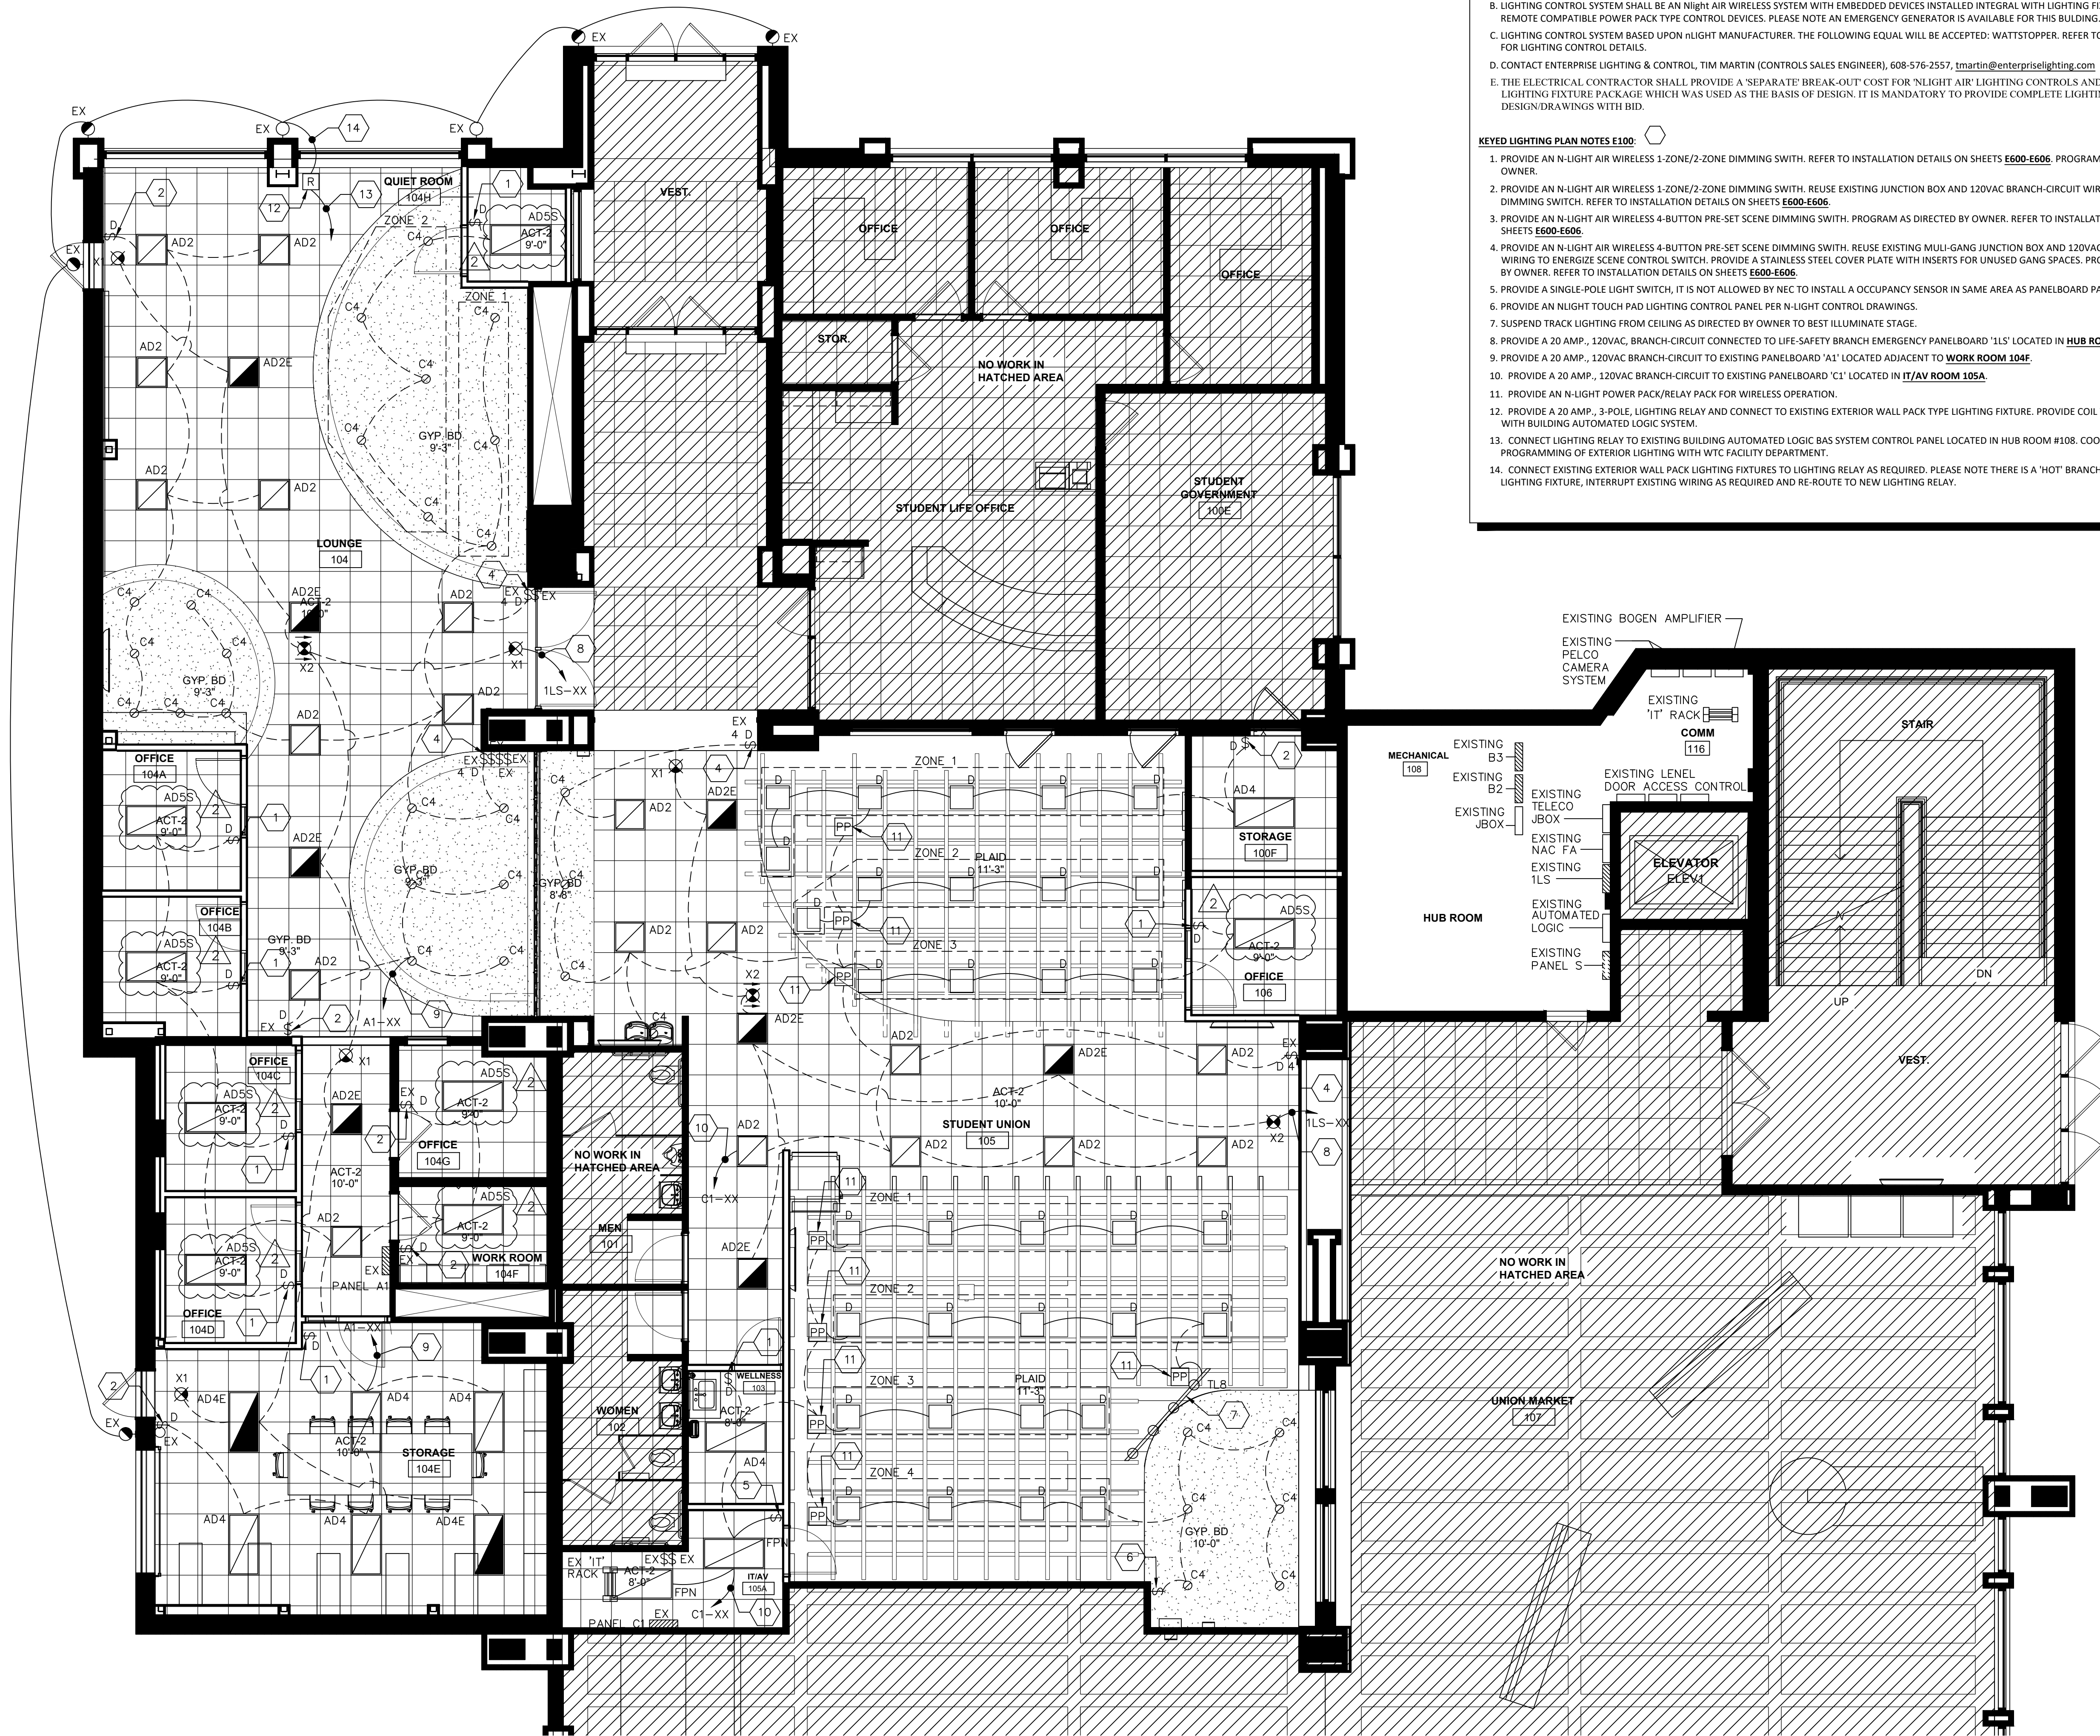

1 ELECTRICAL LIGHTING PLAN



3/16" = 1'-0"

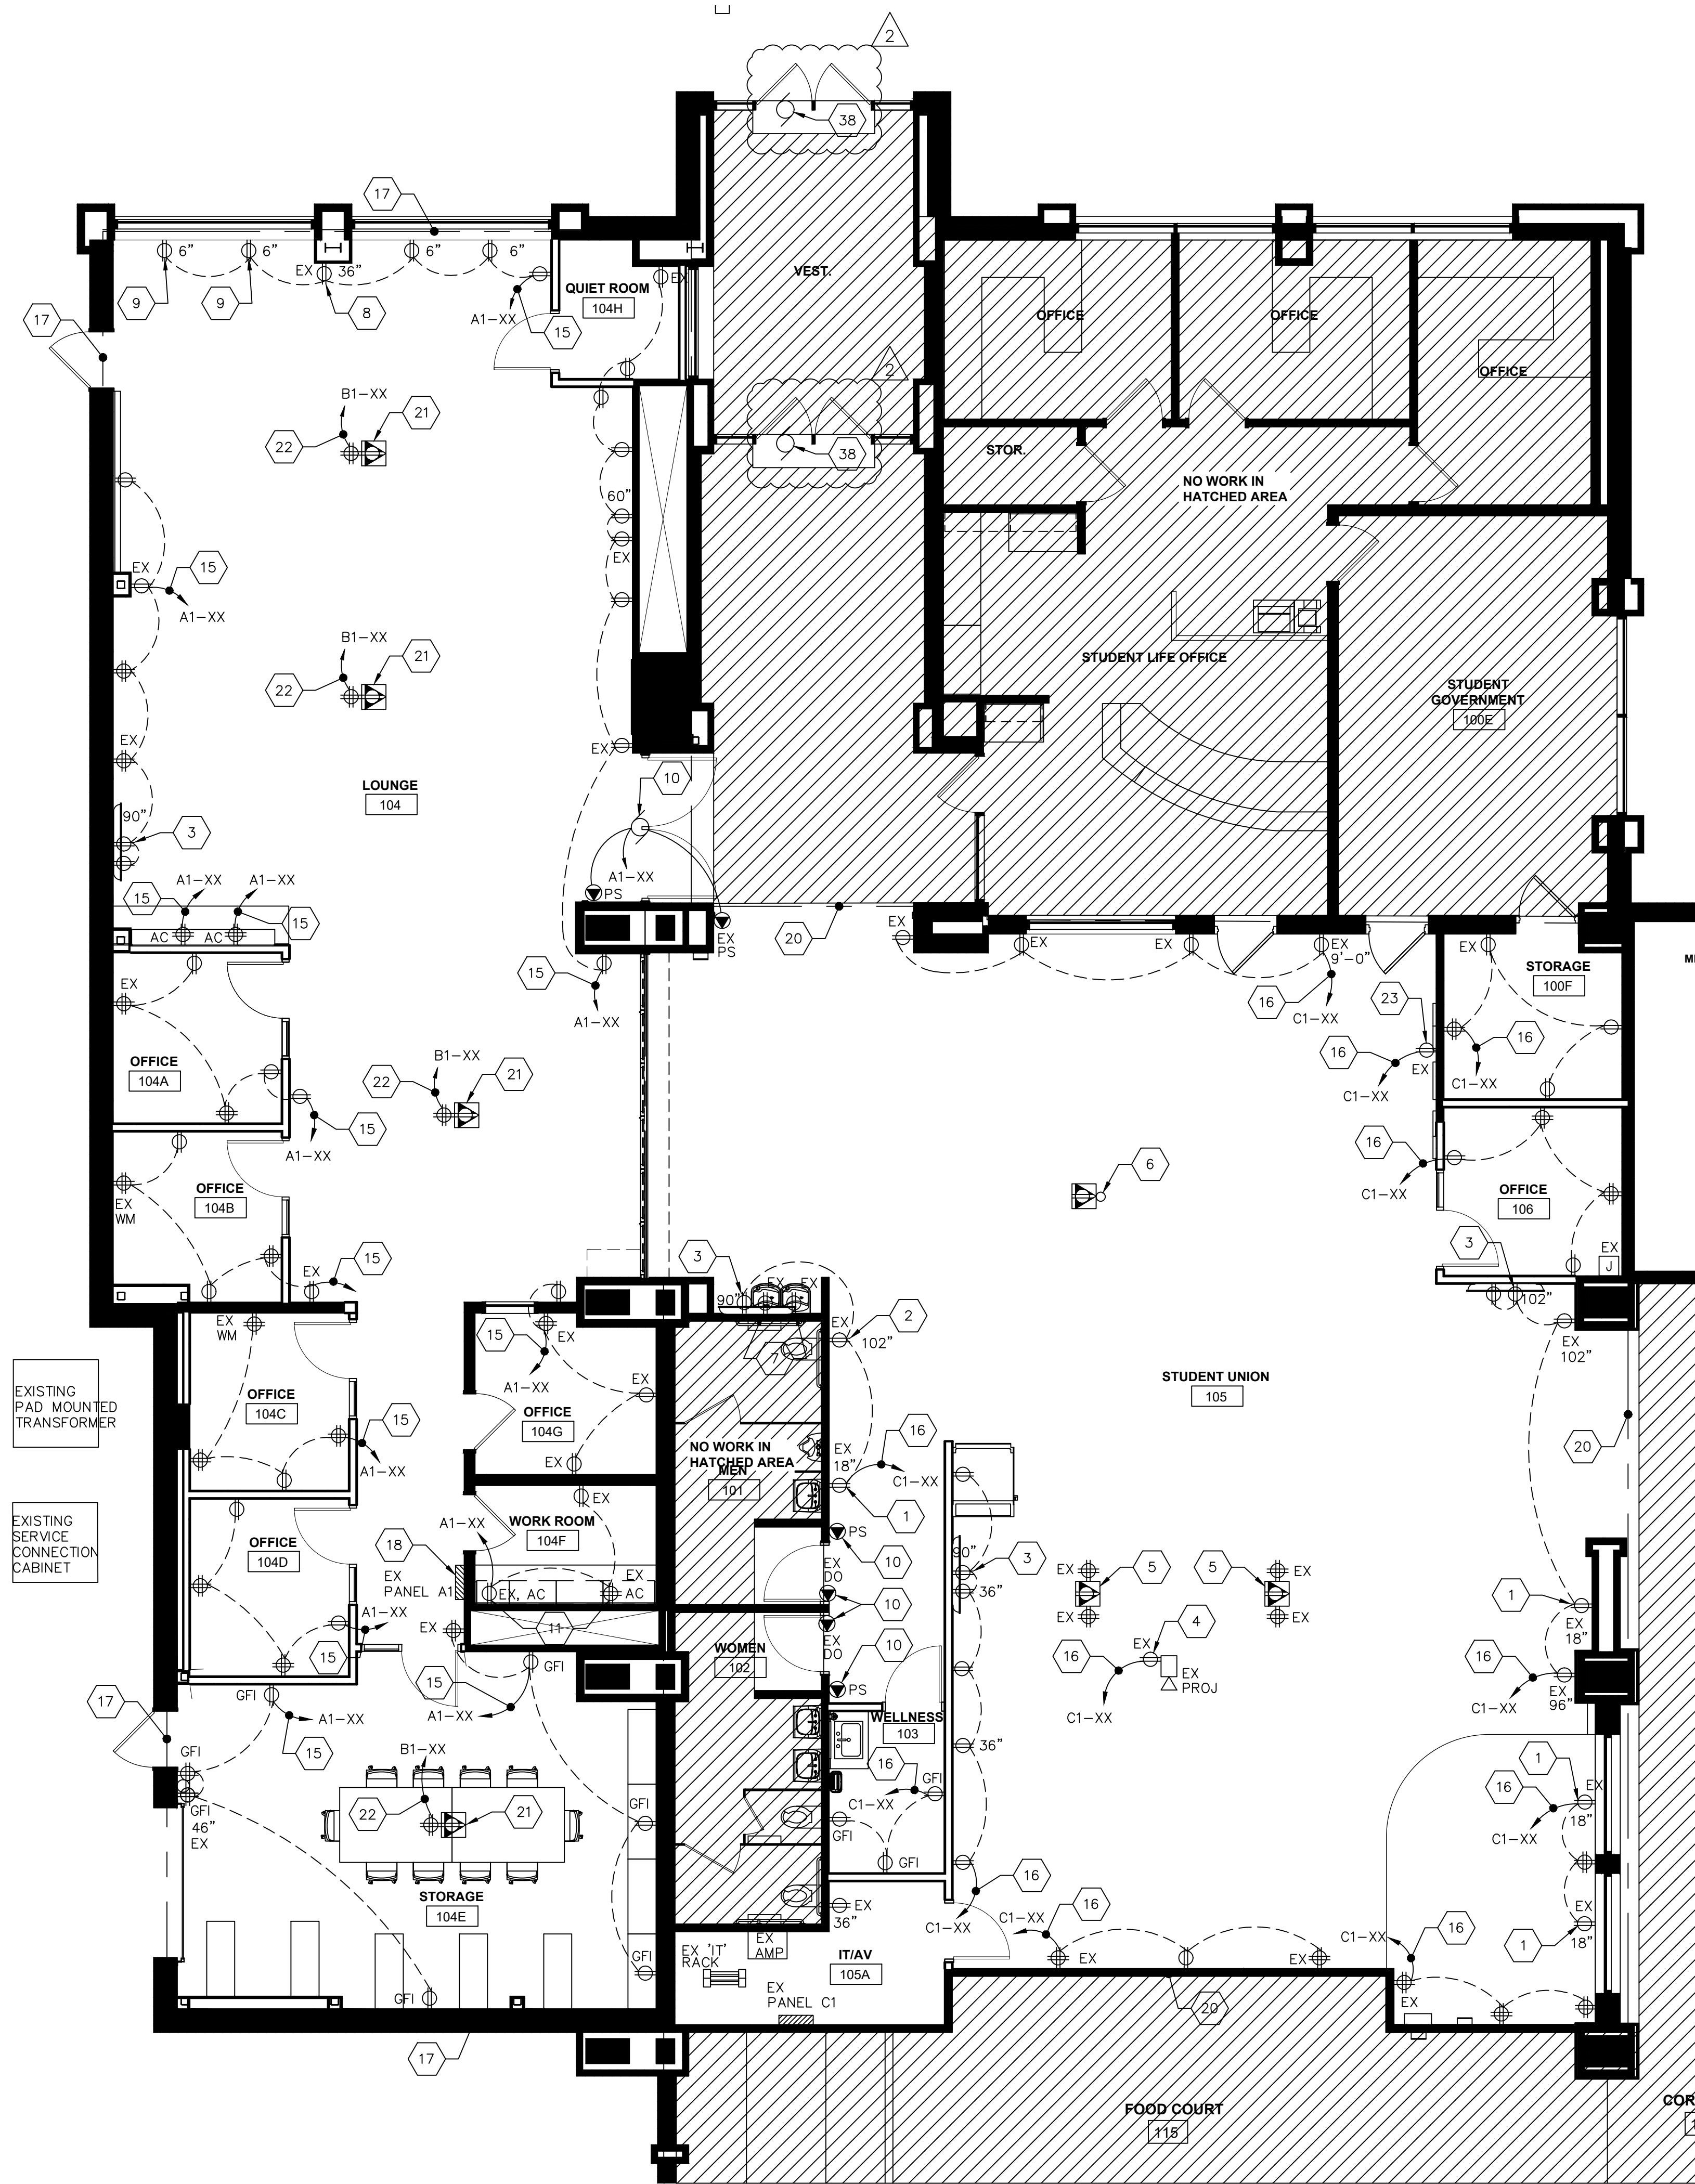


1 ELECTRICAL POWER PLAN
3/16" = 1'-0"

- GENERAL POWER PLAN NOTES:
- A. IT SHALL BE ALLOWED TO REUSE ALL EXISTING JUNCTION BOXES, CONDUIT, STRAPS, FITTINGS, BRANCH-CIRCUIT WIRING TO THE EXTENT POSSIBLE FOR REMODEL WORK.
- B. PROVIDE NEW WIRING DEVICES AND STAINLESS STEEL COVER PLATES IN REMODEL WORK.
- C. SYMBOLS LABELED 'EX' ARE EXISTING JUNCTION BOXES, CONTRACTOR OPTION TO REUSE.
- D. ALL NEW WIRING SHALL BE INSTALLED FLUSH IN EXISTING WALLS. IT WILL BE REQUIRED TO 'FISH' WIRING IN EXISTING WALLS WHERE REASONABLE AND POSSIBLE TO ACCOMPLISH. FOR WALLS WHERE IT IS NOT REASONABLE TO 'FISH' WIRING, THE EXISTING WALL SHALL BE CUT AND CHASED BY ELECTRICAL CONTRACTOR, PATCHING AND PAINTING BY GENERAL CONTRACTOR. SURFACE RACEWAY CONDUIT AND WIREMOLD IS NOT ALLOWED EXCEPT ON BRICK WALLS IN VESTIBULE #107 AND UNION MARKET #107, IT/AV ROOM #105A, COMM ROOM #116, ALL ELECTRICAL, MECHANICAL AND STORAGE ROOMS WHERE EXPOSED CONDUIT AND WIRING IS COMMON.
- KEYED POWER PLAN NOTES-E200:
1. LOWER EXISTING JUNCTION BOX TO 18" ABOVE FINISH FLOOR. REUSE EXISTING BRANCH-CIRCUIT WIRING TO THE EXTENT POSSIBLE.
 2. PROVIDE A DUPLEX RECEPTACLE FOR WALL-MOUNTED MONITOR, REUSE EXISTING JUNCTION BOX AND BRANCH-CIRCUIT WIRING TO THE EXTENT POSSIBLE.
 3. PROVIDE A DUPLEX RECEPTACLE FOR WALL-MOUNTED MONITOR, 'FISH' WIRING INSIDE EXISTING WALL IF POSSIBLE. OTHERWISE PROVIDE WIREMOLD 500/700 AND INSTALL VERTICALLY FROM ABOVE SUSPENDED CEILING. FIELD VERIFY MOUNTING HEIGHT WITH WTC IT DEPARTMENT.
 4. PROVIDE A DUPLEX RECEPTACLE FOR OVERHEAD PROJECTOR, REUSE EXISTING JUNCTION BOX AND BRANCH-CIRCUIT WIRING TO THE EXTENT POSSIBLE.
 5. PROVIDE A NEW COVER PLATE FOR EXISTING FLOOR BOX, CONTACT 'WIREMOLD' REPRESENTATIVE FOR EXACT MODEL NUMBERS. COORDINATE WITH WTC FACILITY DEPARTMENT. PLEASE NOTE DATA JACKS NO LONGER REQUIRED. REFER TO PHOTO #1/E200.
 6. FIELD VERIFY LOCATION OF EXISTING UNDERGROUND CONDUIT STUB-UP FROM REMOVED FURNITURE WALL. AT CONDUIT STUB-UP LOCATION, INSTALL A WIREMOLD FLOOR BOX, COORDINATE WITH 'WIREMOLD' REPRESENTATIVE FOR RECOMMENDED POWER ONLY IN-FLOOR JUNCTION BOX, FITTINGS, AND COVER PLATE MODEL NUMBERS. SAW-CUT EXISTING CONCRETE FLOOR AS REQUIRED. REUSE EXISTING BRANCH-CIRCUIT WIRING TO THE EXTENT POSSIBLE.
 7. EXISTING DUPLEX RECEPTACLES FOR WATER COOLERS TO REMAIN AS IS. FIELD VERIFY THAT RECEPTACLES ARE GFCI PROTECTED. IF NOT, REPLACE WITH GFCI RECEPTACLES OR CONNECT TO GFCI CIRCUIT BREAKER FEEDING THIS BRANCH-CIRCUIT.
 8. RAISE EXISTING JUNCTION BOX TO 36" ABOVE FINISH FLOOR, REUSE EXISTING BRANCH-CIRCUIT WIRING TO THE EXTENT POSSIBLE.
 9. INSTALL RECEPTACLE BELOW WINDOW SILL.
 10. RECONNECT EXISTING MOTORIZED DOOR OPENER. PLEASE NOTE A NEW REPLACEMENT DOOR WAS INSTALLED IN THIS LOCATION. IT WILL BE REQUIRED TO DISCONNECT EXISTING DOOR OPENER AND ASSOCIATED PADDLE CONTROL SWITCHES FROM REMOVED DOOR AND RECONNECT TO NEW DOOR OPENER. REUSE EXISTING BRANCH-CIRCUIT WIRING AND LOW VOLTAGE PADDLE SWITCH CONTROLLERS TO THE EXTENT POSSIBLE. IT WILL BE REQUIRED TO RE-WIRE AND RE-INSTALL EXISTING PADDLE SWITCH CONTROLLERS DUE TO REMODEL WORK. FIELD VERIFY SCOPE OF WORK PRIOR TO SUBMITTING BID.
 11. RAISE EXISTING JUNCTION BOX TO 46" ABOVE FINISH FLOOR, REUSE EXISTING BRANCH-CIRCUIT WIRING TO THE EXTENT POSSIBLE. RECEPTACLE SHALL BE INSTALLED ABOVE COUNTER.
 12. PROVIDE A DUPLEX RECEPTACLE FOR ATM MACHINE. CONNECT TO A GFCI CIRCUIT BREAKER.
 13. PROVIDE A DUPLEX RECEPTACLE FOR VENDING MACHINE. CONNECT TO A GFCI CIRCUIT BREAKER.
 14. DISCONNECT EXISTING 100 AMP, 120/208VAC, 3-PHASE, 4-WIRE, M.L.O., 42-SPACE 'GENERAL ELECTRIC' PANELBOARD AND REPLACE WITH A 125 AMP, 120/208VAC, 3-PHASE, 4-WIRE, 42-SPACE 'SQUARE D' PANELBOARD (ONLY). NO EQUALS ACCEPTED. THIS WORK SHALL BE INCLUDED WITH ALTERNATE BID #3. REFER TO PHOTOS #5/E202 AND #6/E202.
 15. PROVIDE A 20 AMP, 120VAC BRANCH-CIRCUIT TO EXISTING PANELBOARD 'A1' LOCATED ADJACENT TO WORK ROOM #104F. PROVIDE A SQUARE 'D' 20/1 CIRCUIT BREAKER AS REQUIRED.
 16. PROVIDE A 20 AMP, 120VAC BRANCH-CIRCUIT TO EXISTING PANELBOARD 'C1' LOCATED IN IT/AV ROOM #105A. PROVIDE A SQUARE 'D' 20/1 CIRCUIT BREAKER AS REQUIRED.
 17. BRANCH-CIRCUITS IN THIS AREA OF REMODEL PROJECT SHALL BE CONNECTED TO EXISTING PANELBOARD 'A1' LOCATED ADJACENT TO WORK ROOM #104F.
 18. EXISTING 400 AMP, 120/208VAC, 3-PHASE, 4-WIRE, SQUARE 'D' PANELBOARD 'A1'. REUSE EXISTING CIRCUIT BREAKERS TO THE EXTENT POSSIBLE, OTHERWISE PROVIDE NEW SQUARE 'D' CIRCUIT BREAKERS AS REQUIRED.


19. EXISTING 125 AMP, 120/208VAC, 3-PHASE, 4-WIRE, SQUARE 'D' PANELBOARD 'C1'. REUSE EXISTING CIRCUIT BREAKERS TO THE EXTENT POSSIBLE, OTHERWISE PROVIDE NEW SQUARE 'D' CIRCUIT BREAKERS AS REQUIRED.
20. BRANCH-CIRCUITS IN THIS AREA OF REMODEL PROJECT SHALL BE CONNECTED TO EXISTING PANELBOARD 'C1' LOCATED IN IT/AV ROOM #105A.
21. PROVIDE A 'WIREMOLD', MODEL #6AT, POKE THRU DEVICE, FLUSH STYLE COVER, BLACK COLOR, POWER DOUBLE DUPLEX RECEPTACLE ONLY. CORE DRILL APPROXIMATELY 12" THICK CONCRETE FLOOR AS REQUIRED. THIS WORK SHALL BE BID AS ALTERNATE BID #2. PROVIDE A COMBINATION POWER AND DATA FLOOR BOX INSTALLED IN STORAGE ROOM #104E FOR CONFORMANCE TABLE.
22. PROVIDE A 20 AMP, 120VAC, BRANCH-CIRCUIT CONNECTED TO PANELBOARD 'B1' LOCATED IN THE BASEMENT. REFER TO BASEMENT PLAN 3/E200 FOR LOCATION OF PANELBOARD. INCLUDE WITH ALTERNATE BID #2.
23. THIS WALL WILL BECOME A VIDEO DIGITAL PICTURE FRAME WALL WITH EIGHT (8) VIDEO DIGITAL PICTURE FRAME SCREENS. PROVIDE EIGHT (8) RECESSED DUPLEX RECEPTACLES, ONE (1) BEHIND EACH VIDEO DIGITAL SCREEN. PROVIDE EIGHT (8) COMBINATION LOW VOLTAGE/POWER RECESSED TWO GANG METAL JUNCTION BOXES, ONE FOR EACH VIDEO DIGITAL SCREEN. THE INTENT IS TO HAVE A RECESSED JUNCTION BOX BEHIND EACH VIDEO DIGITAL SCREEN TO CONCEAL POWER CORD AND LOW VOLTAGE CORDS. APPROVED MANUFACTURERS ARE 'CHIEF', 'LEVITON', 'ARLINGTON', 'LEGRAND', 'HUBBELL' OR APPROVED EQUAL. REFER TO ARCHITECTURAL SHEET 5/A400. COORDINATE THOROUGHLY WITH WTC IT DEPARTMENT FOR MOUNTING HEIGHTS PRIOR TO ROUGHING-IN JUNCTION BOXES AND CONDUITS.
24. PROVIDE A SQUARE 'D' EMERGENCY BOILER SHUT-DOWN SWITCH WITH MUSHROOM TYPE HEAD, MODEL #9021K14 OR EQUAL, CLEARLY LABEL "BOILER EMERGENCY SHUT-DOWN". CONNECT TO SHUNT-TRIP BREAKERS FEEDING BOILERS IN PANELBOARD 'E2'. PROVIDE A 20 AMP, 120VAC CONTROL CIRCUIT AS REQUIRED FED FROM PANELBOARD 'E2'.
25. EXISTING SQUARE 'D' 600 AMP, 1-LINE 120/208VAC, 3-PHASE, 4-WIRE EMERGENCY DISTRIBUTION PANELBOARD 'ED' PANELBOARD TO REMAIN AS IS. USE EXISTING 200 AMP, 3-POLE CIRCUIT BREAKER TO FEED PANELBOARD 'E2'.
26. PROVIDE 4 #3/0 THWN-2 AND 1 #6 THWN-2 (GRO) IN 2" EMT CONDUIT FEEDER.
27. EXISTING SQUARE 'D' NQ 225 AMP, 120/208VAC, 3-PHASE, 4-WIRE PANELBOARD. DISCONNECT PANELBOARD FED FROM ADJACENT PANELBOARD 'B1' AND RE-FEED FROM EMERGENCY PANEL 'ED'. PLEASE NOTE IT IS FED WITH A 100/3 CIRCUIT BREAKER FROM PANEL 'B1' AT PRESENT. RELABEL AS 'E2'.
28. EXISTING SQUARE 'D' NQ 400 AMP, 120/208VAC, 3-PHASE, 4-WIRE PANELBOARD 'B1'.
29. EXISTING HVAC TEMPERATURE CONTROL PANEL SHALL BE DISCONNECTED FROM PRESENT POWER SOURCE AND RECONNECTED TO EMERGENCY PANELBOARD 'E' OR 'E2'. PROVIDE A 20 AMP, 120VAC BRANCH-CIRCUIT AND CONNECT TO EMERGENCY PANELBOARD 'E' OR 'E2'.
30. DISCONNECT PUMP #2 FROM PANELBOARD 'B1' (BRANCH-CIRCUIT #B1-8,10,12) AND RECONNECT TO PANELBOARD 'E2' (E2-52,54,56). REUSE EXISTING 35/3 CIRCUIT BREAKER FROM PANELBOARD 'B1' AND REINSTALL IN PANELBOARD 'E2'.
31. DISCONNECT PUMP #1 FROM PANELBOARD 'B1' (BRANCH-CIRCUIT #B1-7,9,11) AND RECONNECT TO PANELBOARD 'E2' (E2-49,51,53). REUSE EXISTING 35/3 CIRCUIT BREAKER FROM PANELBOARD 'B1' AND REINSTALL IN PANELBOARD 'E2'.
32. EXISTING BOILER CONNECTED TO EMERGENCY PANELBOARD 'E2'. PROVIDE ONE (1) 20/3 SHUNT-TRIP CIRCUIT BREAKER FOR BRANCH-CIRCUIT #E2-43,45,47 AND ONE (1) 20/1 SHUNT-TRIP CIRCUIT BREAKER FOR BRANCH-CIRCUIT #E2-50 FOR EMERGENCY SHUT-DOWN OF BOILERS. CONNECT SHUNT-TRIP BREAKERS TO EMERGENCY BOILER SHUT-OFF SWITCH.
33. EXISTING SQUARE 'D' NQ 225 AMP, 120/208VAC, 3-PHASE, 4-WIRE PANELBOARD 'E' TO REMAIN AS IS.
34. EXISTING SQUARE 'D' NQ 225 AMP, 120/208VAC, 3-PHASE, 4-WIRE PANELBOARD 'EE' TO REMAIN AS IS. PLEASE NOTE THIS IS THE 'LIFE-SAFETY' BRANCH OF THE EMERGENCY SYSTEM. 1ST FLOOR EMERGENCY LIGHTING IS FED FROM THIS PANELBOARD AT PRESENT.
35. DISCONNECT EXISTING HOT WATER PUMP #3 FROM PRESENT NON-EMERGENCY PANELBOARD 'PDA' (BRANCH CIRCUIT #PDA-25,27,29) AND RECONNECT TO EMERGENCY PANELBOARD 'E' (E-55,57,59). PROVIDE A 35/3 CIRCUIT BREAKER IN PANELBOARD 'E'.
36. CONNECT RECEPTACLE TO NEAREST AVAILABLE 120VAC POWER SOURCE. MONITOR DRAWS SMALL AMOUNT OF LOAD.
37. EXISTING BOILER PUMP CONNECTED TO EMERGENCY PANELBOARD 'E2' (E2-44,46,48). NO WORK REQUIRED.
38. RECONNECT NEW REPLACEMENT MOTORIZED DOOR OPENER INSTALLED ON EXISTING DOOR. IT WILL BE REQUIRED TO DISCONNECT EXISTING DOOR OPENER AND ASSOCIATED PADDLE CONTROL SWITCHES FROM EXISTING DOOR AND RECONNECT TO NEW REPLACEMENT DOOR OPENER. REUSE EXISTING BRANCH-CIRCUIT WIRING AND LOW VOLTAGE PADDLE SWITCH CONTROLLERS TO THE EXTENT POSSIBLE. FIELD VERIFY SCOPE OF WORK PRIOR TO SUBMITTING BID.

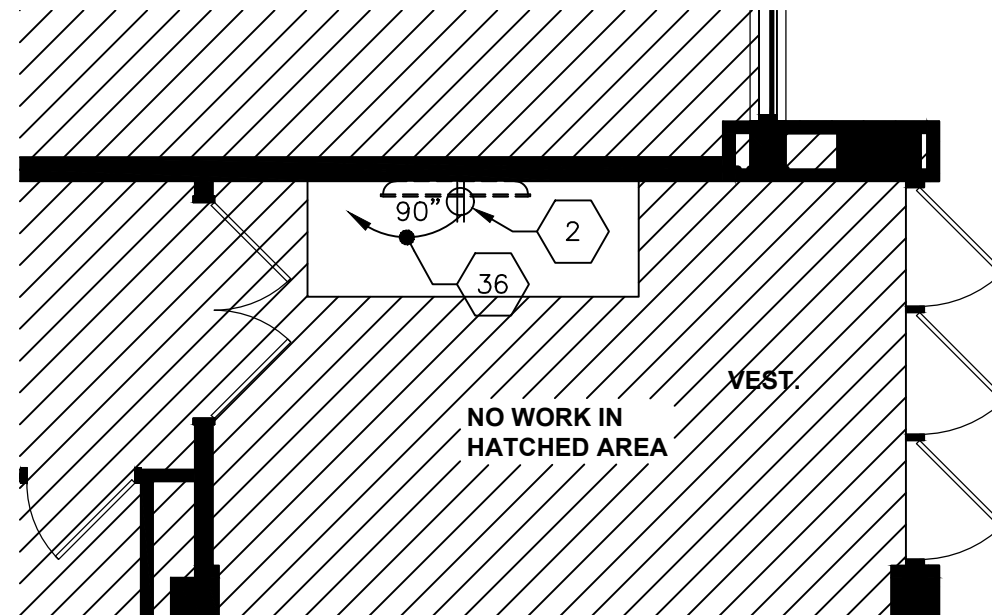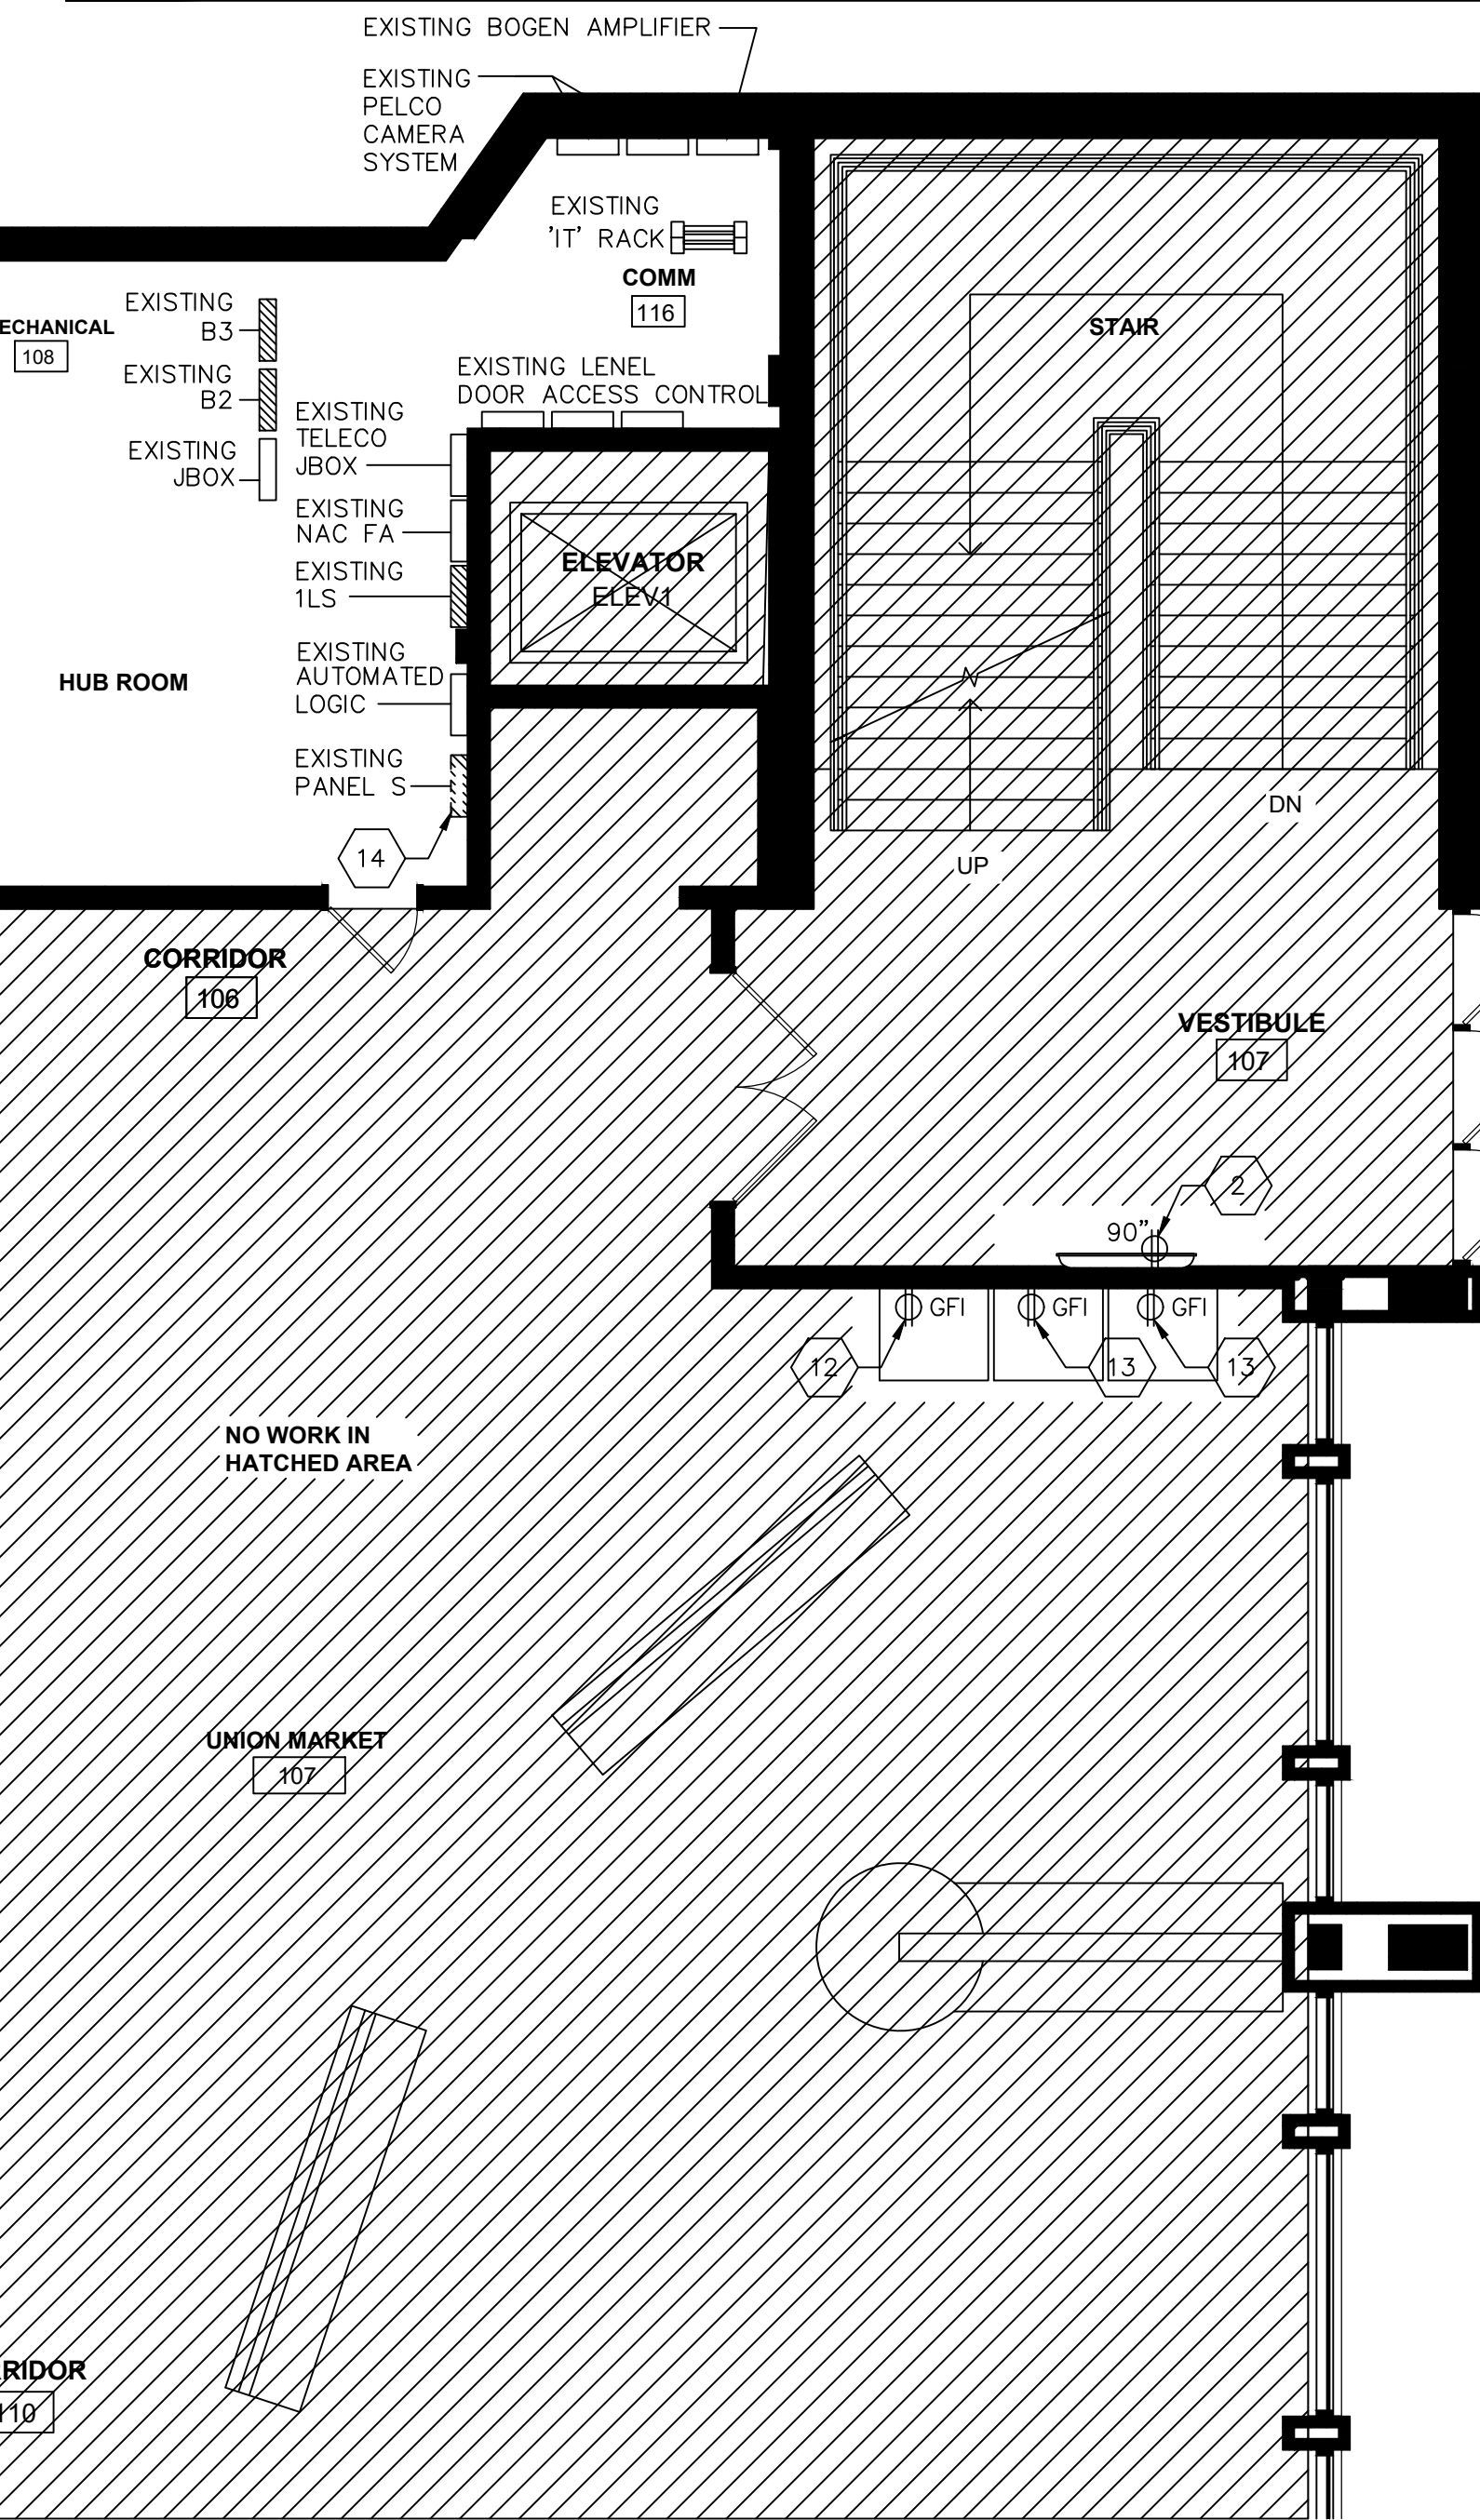

2 SW VESTIBULE
3/16" = 1'-0"

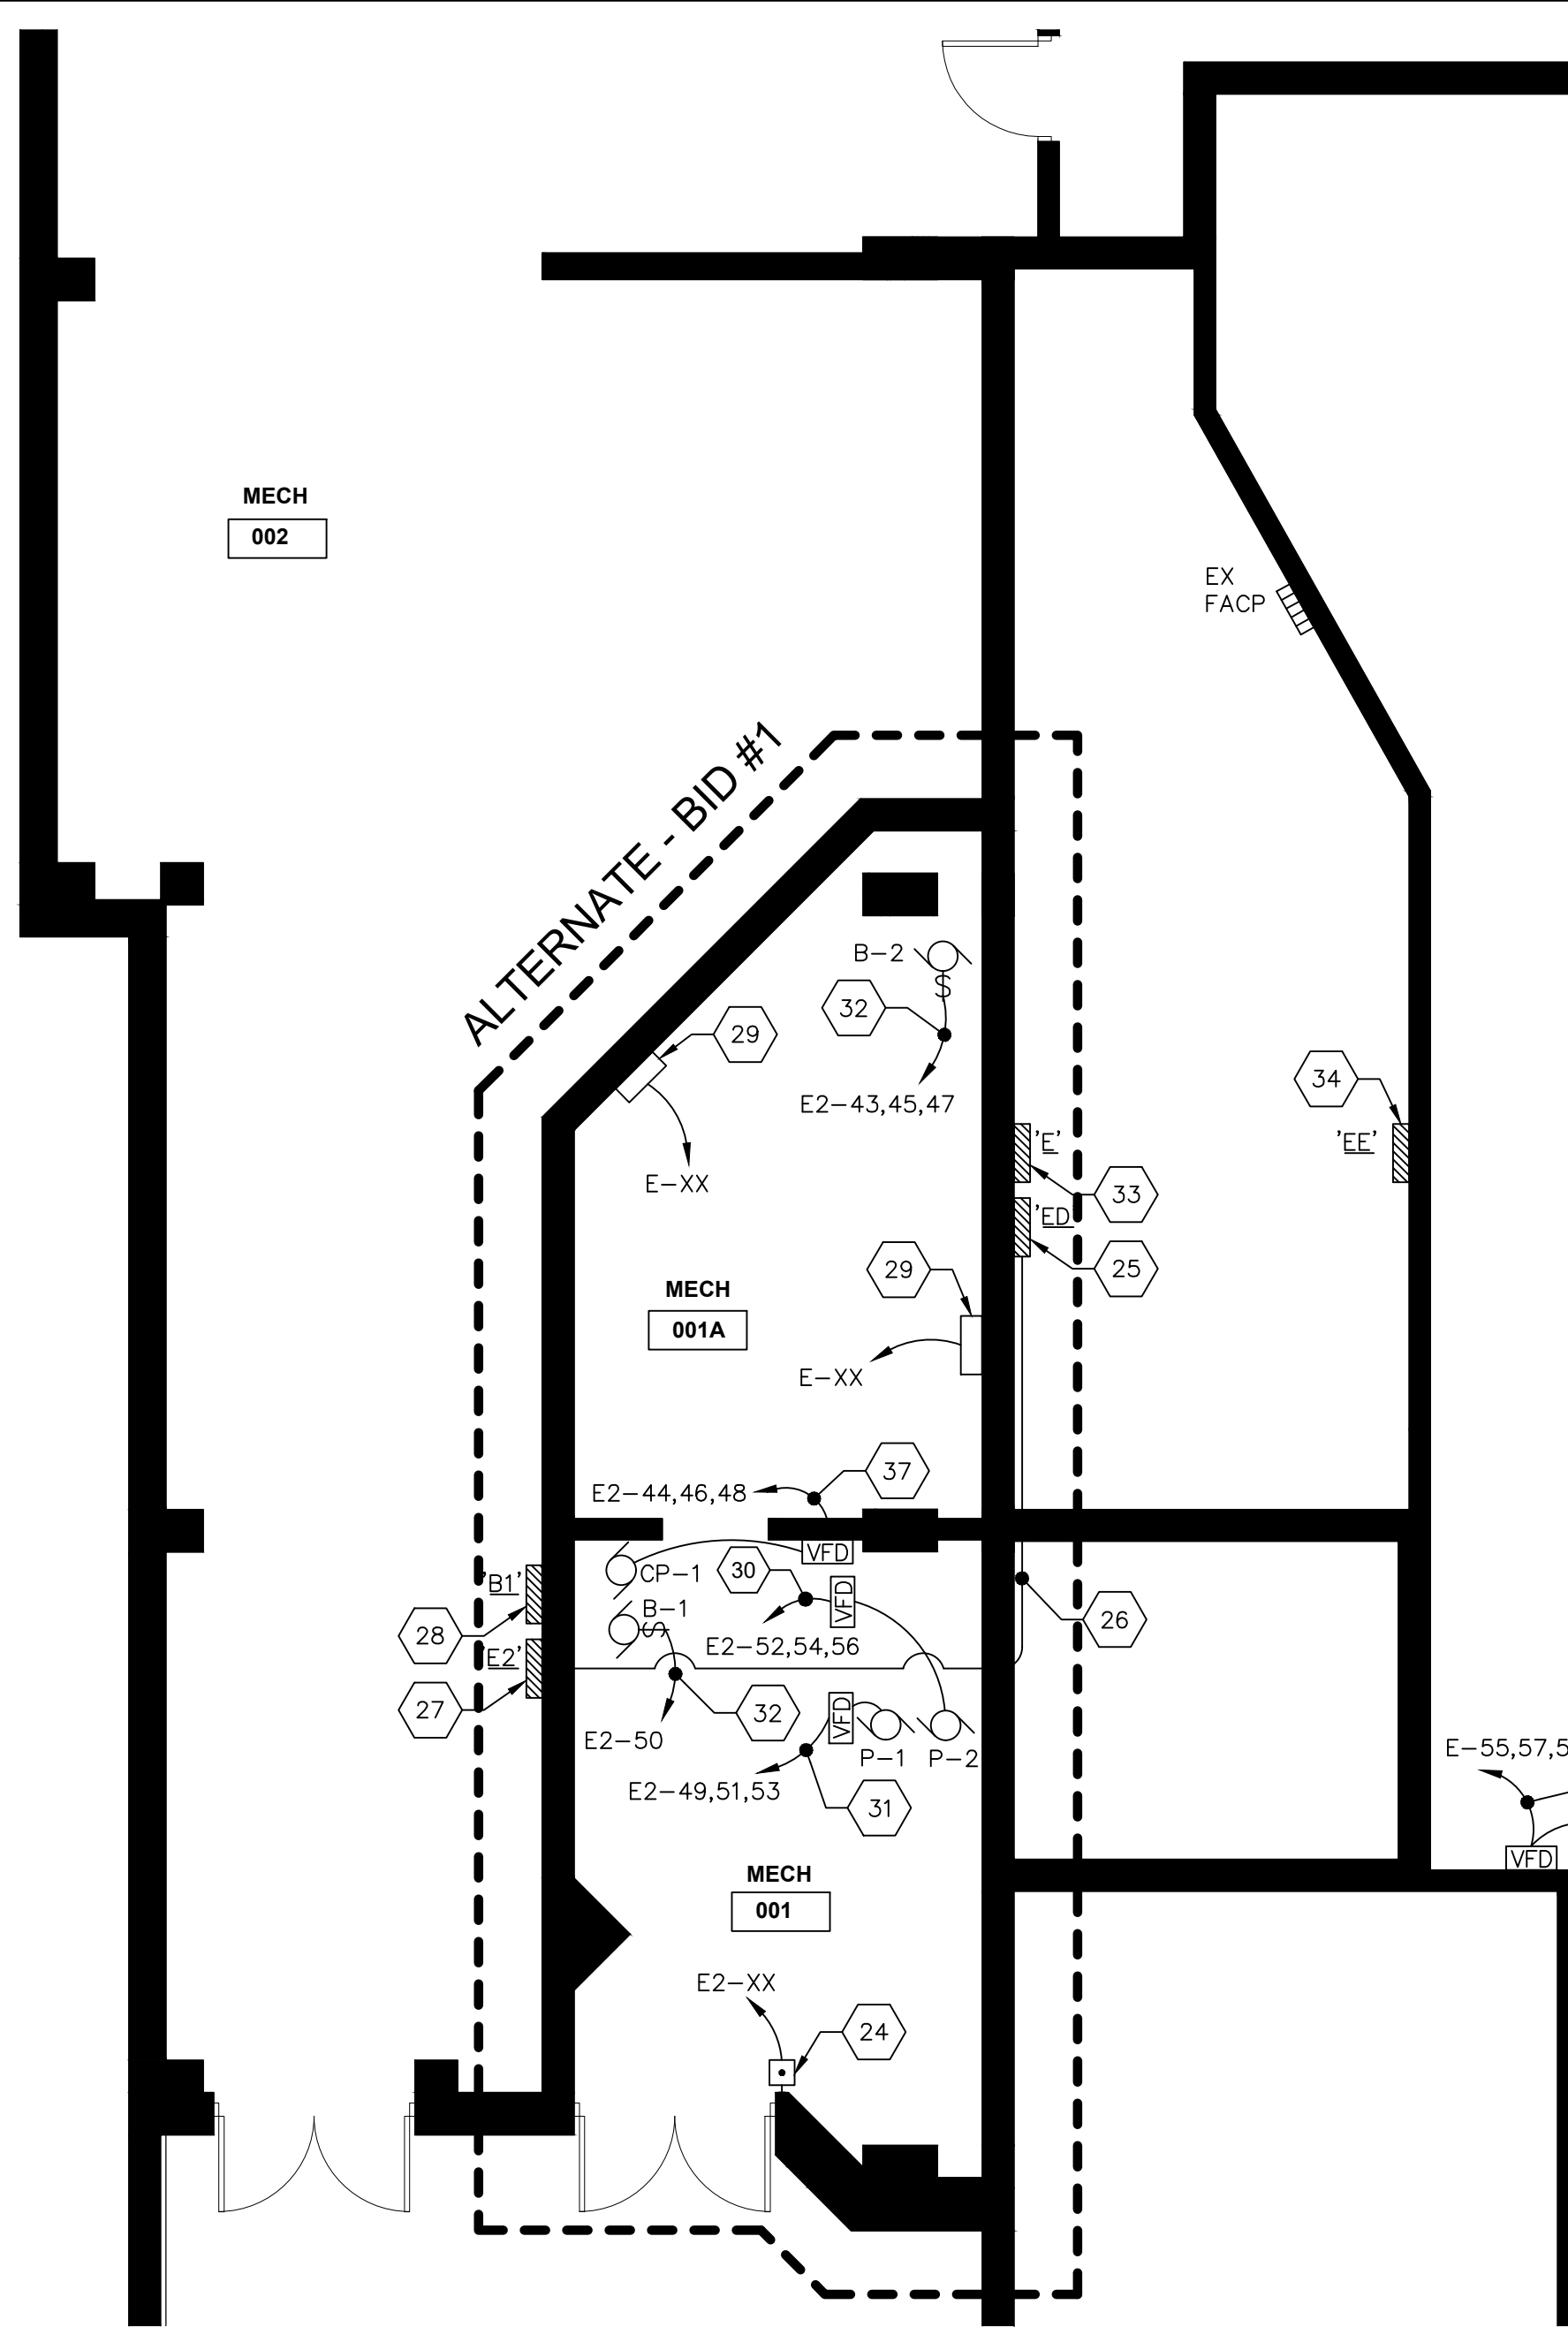

3 BASEMENT PLAN
3/16" = 1'-0"

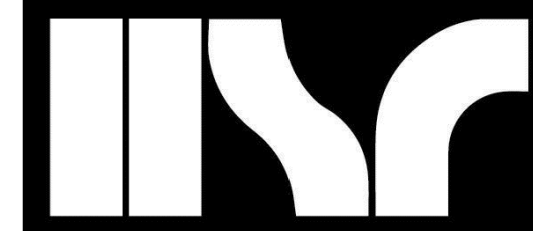

HSR ASSOCIATES INC.
100 MILWAUKEE STREET
LA CROSSE, WISCONSIN
PHONE: 608.782.1830
FAX: 608.782.5844
www.hsrassociates.com

Consultant:



4045 LINDA STREET, SUITE 101
LA CROSSE, WISCONSIN 54601
PHONE: 608.782.1830
FAX: 608.782.5844
EMAIL: info@galileiconsulting.com

WESTERN TECHNICAL COLLEGE
KUMM STUDENT UNION REMODEL

Project Title:

HSR Project Number:
25041

Project Date:
FEBRUARY 2026

Drawn By:
PLP

Key Plan:

Project Location: 400 6th St. N.
La Crosse WI 54601


Sheet Title: ELECTRICAL POWER PLANS

No.	Description	Date
1	ADDENDUM # 2	02/24/26

Graphic Scale:
VARIES

Last Update:
2/03/2026

E200

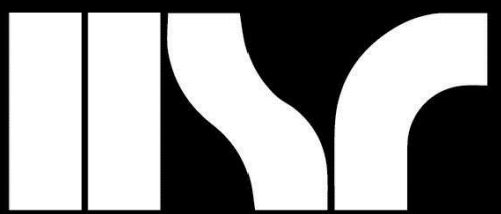

HSR ASSOCIATES INC.
100 MILWAUKEE STREET
LA CROSSE, WISCONSIN
PHONE: 608.784.1830
FAX: 608.782.5844
www.hsrassociates.com

Consultant:



2045 LINDA STREET, SUITE 111
LA CROSSE, WISCONSIN 54601
PHONE: 608.784.1830
FAX: 608.782.5844
E-MAIL: info@galileo-consulting.com

WESTERN TECHNICAL COLLEGE
KUMM STUDENT UNION REMODEL
Project Title:
Project Location:
400 6th St. N.
La Crosse WI 54601
Sheet Title:
ELECTRICAL SCHEDULES

HSR Project Number:
25041

Project Date:
FEBRUARY 2026

Drawn By:
PLP

Key Plan:

Revisions:		
No.	Description	Date
ADD	ADDENDUM # 2	02/24/26

Graphic Scale:
VARIES

Last Update:
2/03/2026

E500

LIGHTING FIXTURE SCHEDULE													
TYPE	QTY	MANUFACTURER	CATALOG NUMBER	DESCRIPTION	VOLT	MOUNTING			LAMPS/LIGHT SOURCE		WATTS/ FIXTURE	REMARKS	
						F	S	*	COLOR	LUMENS			TYPE
AD2		ACUITY	STAK-2X2-3000LM-80CRI-40K-COL-MINI-ZT-NLTAIR2	2'X2' LED LAYIN TROFFER, CURVED RIBBED CENTER BASKET, UNIVERSAL VOLTAGE, DIMMING, ADJUSTABLE LUMEN, ADJUSTABLE COLOR TEMP., NLIGHT AIR	MMLT	X			35-50	3040/50	LED 0-10VDC DIMMING	26-46	1
AD2S		ACUITY	STAK-2X2-3000LM-80CRI-40K-COL-MINI-ZT-NLTAIR2-APDT	2'X2' LED LAYIN TROFFER, CURVED RIBBED CENTER BASKET, UNIVERSAL VOLTAGE, DIMMING, ADJUSTABLE LUMEN, ADJUSTABLE COLOR TEMP., NLIGHT AIR	MMLT	X			35-50	3040/50	LED 0-10VDC DIMMING	26-46	1
AD2-E		ACUITY	STAK-2X2-3000LM-80CRI-40K-COL-MINI-ZT-NLTAIREM2	2'X2' LED LAYIN TROFFER, CURVED RIBBED CENTER BASKET, UNIVERSAL VOLTAGE, DIMMING, ADJUSTABLE LUMEN, ADJUSTABLE COLOR TEMP., NLIGHT AIR, EMER	MMLT	X			35-50	3040/50	LED 0-10VDC DIMMING	26-46	1
AD4		ACUITY	STAK-2X4-5000LM-80CRI-40K-COL-MINI-ZT-NLTAIR2	2'X4' LED LAYIN TROFFER, CURVED RIBBED CENTER BASKET, UNIVERSAL VOLTAGE, DIMMING, ADJUSTABLE LUMEN, ADJUSTABLE COLOR TEMP., NLIGHT AIR	MMLT	X			35-50	5060/70	LED 0-10VDC DIMMING	36-60	1
AD4S		ACUITY	STAK-2X4-5000LM-80CRI-40K-COL-MINI-ZT-NLTAIR2-APDT	2'X4' LED LAYIN TROFFER, CURVED RIBBED CENTER BASKET, UNIVERSAL VOLTAGE, DIMMING, ADJUSTABLE LUMEN, ADJUSTABLE COLOR TEMP., NLIGHT AIR	MMLT	X			35-50	5060/70	LED 0-10VDC DIMMING	26-46	1
AD4-E		ACUITY	STAK-2X4-5000LM-80CRI-40K-COL-MINI-ZT-NLTAIREM2	2'X4' LED LAYIN TROFFER, CURVED RIBBED CENTER BASKET, UNIVERSAL VOLTAGE, DIMMING, ADJUSTABLE LUMEN, ADJUSTABLE COLOR TEMP., NLIGHT AIR, EMER	MMLT	X			35-50	3040/50	LED 0-10VDC DIMMING	26-46	1
AD6S		ACUITY	STAK-2X4-6000LM-80CRI-40K-COL-MINI-ZT-NLTAIR2-APDT	2'X4' LED LAYIN TROFFER, CURVED RIBBED CENTER BASKET, UNIVERSAL VOLTAGE, DIMMING, FIXED LUMEN, 4000K COLOR TEMP., NLIGHT AIR	MMLT	X			4000K	6000	LED 0-10VDC DIMMING	46	1
C4		ACUITY	LDN4-4X20-L04ARLS-TRV-MVOLT-G21 NLTAIR2	6" RECESSED DOWNLIGHT, 40K, 2000LUMENS, DOWNLIGHT, CLEAR TRIM COLOR, SEMI SPECULAR TRIM COLOR, WHITE FLANGE, 0-10V DIMMING, NLTAIR	MMLT	X			4000K	2000	LED 0-10VDC DIMMING	20	2
D		TGS	ORBS-18-36-40-U-D1-BK-CM10	18"X18" SUSPENDED MOUNT, LED, DECORATIVE, BLACK FINISH	MMLT		X		4000K	2,520	LED 0-10VDC DIMMING	36	2
TL8 H		TIMES SQUARE LIGHTING	JCR42-8040-B-120-48-DT2-010	LED TRACK HEAD, BLACK, QUANTITY OF 4	120			X	4000K	3500	LED 0-10VDC DIMMING	28	2
TL8 TK		TIMES SQUARE LIGHTING	DT8B	8'-0", TWO CIRCUIT, BLACK TRACK	120			X	4000K	3500	LED 0-10VDC DIMMING	28	2
X1/X2		ACUITY	LQM-BBS-RG-MVOLT-M6	LED EXT LIGHT, RED LETTERS, STAINLESS STEEL HOUSING, UNIVERSAL MONTING.	120/277		X				LED	<5	2
REMARKS:													
1	EQUALS ACCEPTED FOR THIS LIGHTING FIXTURE WITH PRIOR APPROVAL ONLY.												
2	EQUALS ACCEPTED FOR THIS LIGHTING FIXTURE.												

Panel- 'S', 125 AMP., 120/208VAC, 3-Phase, M.L.O. 22K

Space No.	Serves	C/B Size/Type	Load (KVA)		Load (KVA)	C/B Size/Type	Serves	Space No.
1	EXISTING	20/1				20/1	EXISTING	2
3	EXISTING	20/1				20/1	EXISTING	4
5	EXISTING	20/1				20/1	EXISTING	6
7	EXISTING	20/1				20/1	EXISTING	8
9	EXISTING	20/1				20/1	EXISTING	10
11	EXISTING	20/1				20/1	EXISTING	12
13	EXISTING	20/1				20/1	EXISTING	14
15	EXISTING	40/2				20/1	EXISTING	16
17	EXISTING	40/2				20/1	EXISTING	18
19	EXISTING	20/1				20/1	EXISTING	20
21	EXISTING	20/1				20/1	EXISTING	22
23	EXISTING	20/1				20/1	EXISTING	24
25	EXISTING	20/1				20/1	EXISTING	26
27	EXISTING	20/1				20/1	EXISTING	28
29	EXISTING	20/2				20/2	EXISTING	30
31	EXISTING	20/2				20/2	EXISTING	32
33	EXISTING	20/1				20/1	EXISTING	34
35	EXISTING	20/1				20/1	EXISTING	36
37	EXISTING	20/1				20/1	EXISTING	38
39	EXISTING	20/1				20/1	EXISTING	40
41	EXISTING	20/1				20/1	EXISTING	42

LIGHTING (KVA):									
RECEPTACLES (KVA):									
MOTOR/EQUIPMENT (KVA):									
TOTAL (KVA):									
Notes:									
1	Provide a 42 space panelboard.								
2	Include with Alternate Bid #3								